



D116

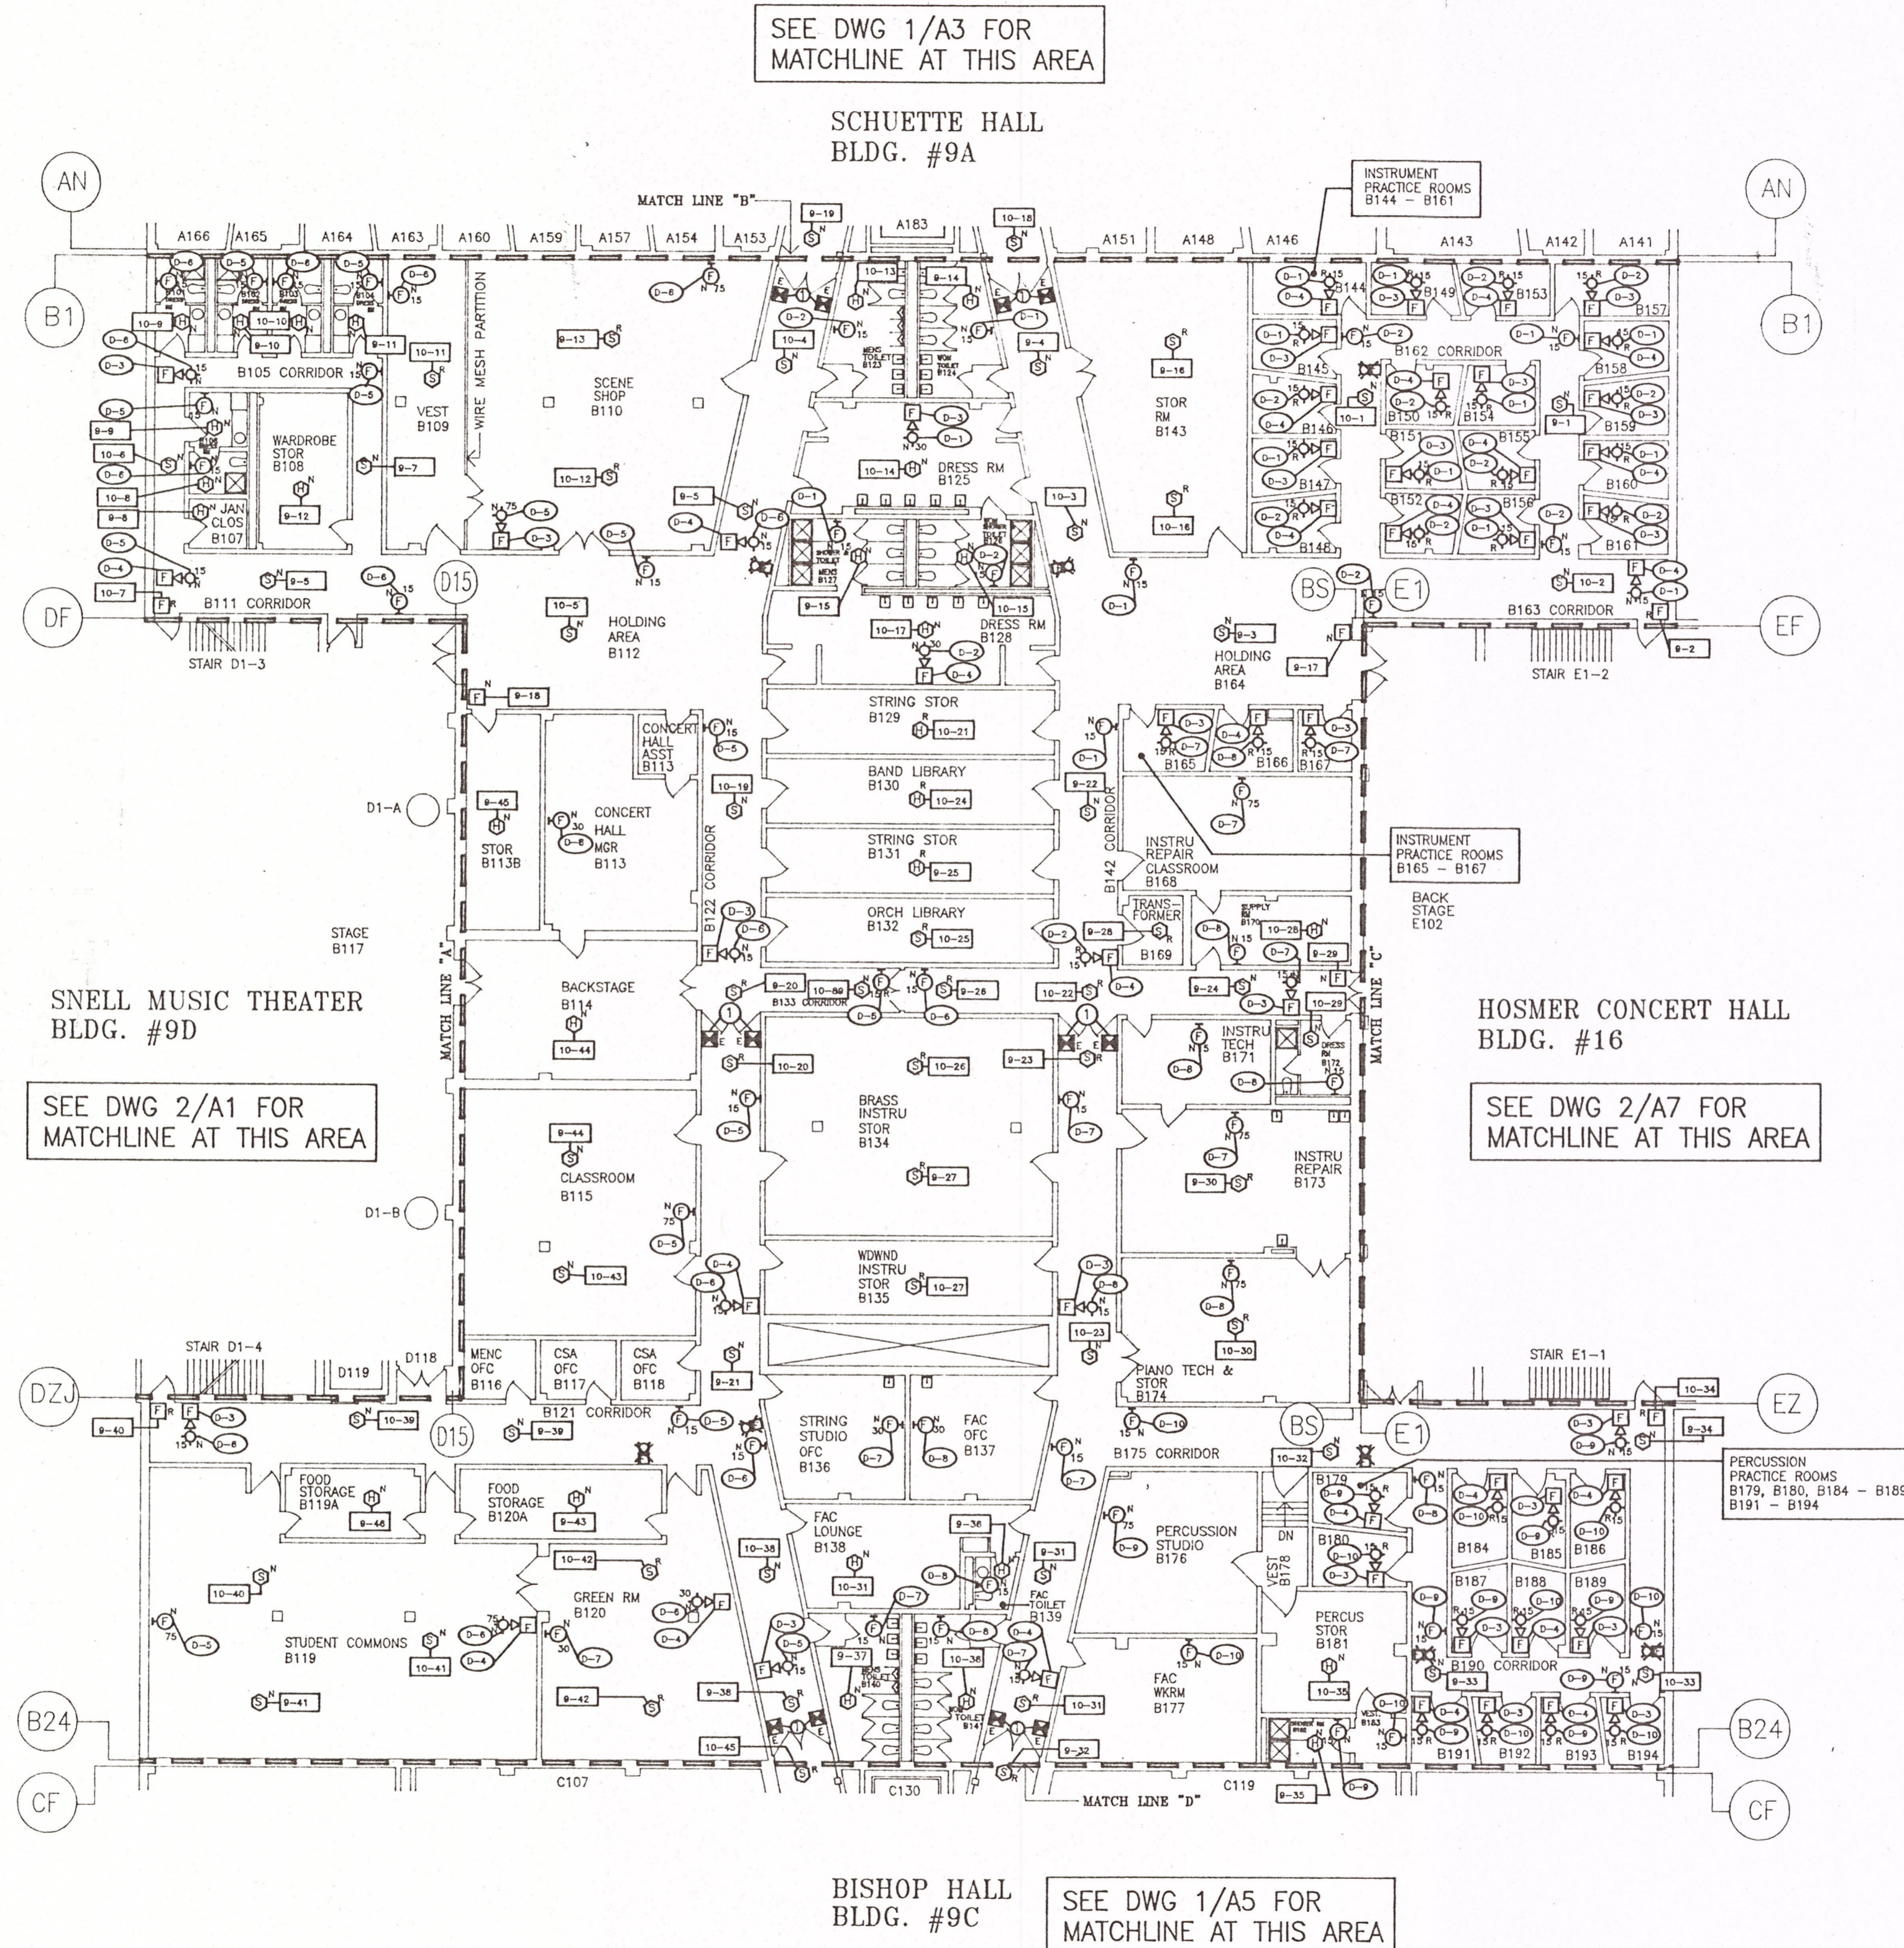

1 LOWER PLAN - LEVEL 1
 A11 SCALE: 1/16" = 1'-0"


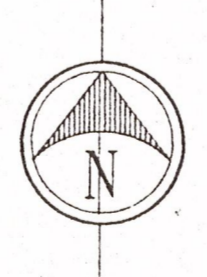


KEY NOTES:

- 1 REWIRE EXISTING DOOR HOLDER TO NEW FIRE ALARM SYSTEM. SEE RISER DIAGRAM AND DETAIL.

CONTRACTOR SHALL CHECK AND FIELD VERIFY ALL DIMENSIONS AND REPORT DISCREPANCIES TO THE ARCHITECT BEFORE ANY WORK IS COMMENCED.
 ALL DRAWINGS ARE THE PROPERTY OF THE ARCHITECT.
 THIS DESIGN AND THESE DOCUMENTS MAY NOT BE REPRODUCED, REUSED, ALTERED OR ADDED TO WITHOUT THE WRITTEN PERMISSION OF THE ARCHITECT.

STATE UNIVERSITY
 CONSTRUCTION FUND
 SUCF PROJECT NUMBER 12130
 REPLACE FIRE ALARM SYSTEM / INSTALL SPRINKLER
 CRANE MUSIC COMPLEX
 STATE UNIVERSITY COLLEGE AT POTSDAM

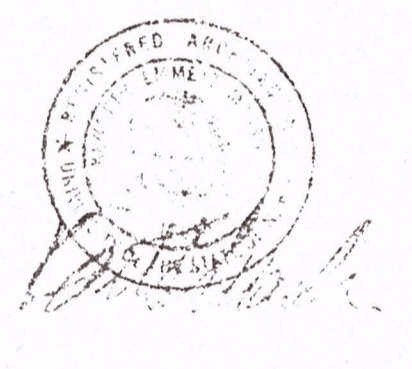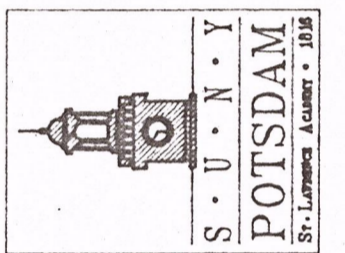

HAZP, CONSULTANTS IN ENGINEERING
 P.O. BOX 228
 CLIFTON PARK, N.Y. 12065
 TEL: (518) 877-8506
 FAX: (518) 877-8509

OCM PROJECT NO. 10233



O'CONNOR & MARSH
 ARCHITECTS

FACILITY DESIGN - PLANNING

517 OVER THE LIBRARY
 WESTERN AVENUE
 ALBANY, NEW YORK 12203
 518 459 0611


DRAWING TITLE
 CRANE MUSIC CENTER - LEVEL 1

DATE
 12-9-97

PROJECT NO.
 12130

DRAWING NO.
A11

KEY PLAN: CRANE MUSIC COMPLEX

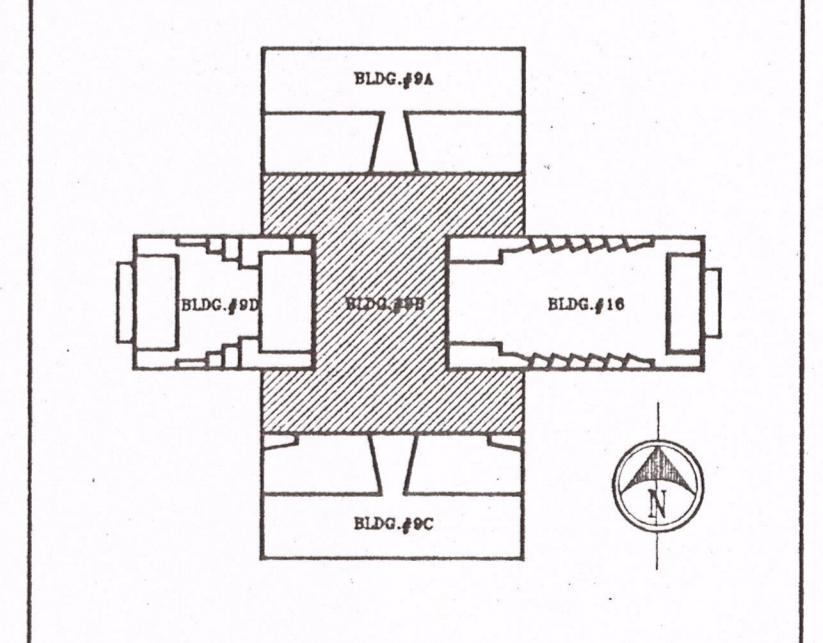

CRANE MUSIC CENTER (BLDG. #9B)