




1 PARTIAL PLAN  
A12 SCALE: 1/4" = 1'-0"

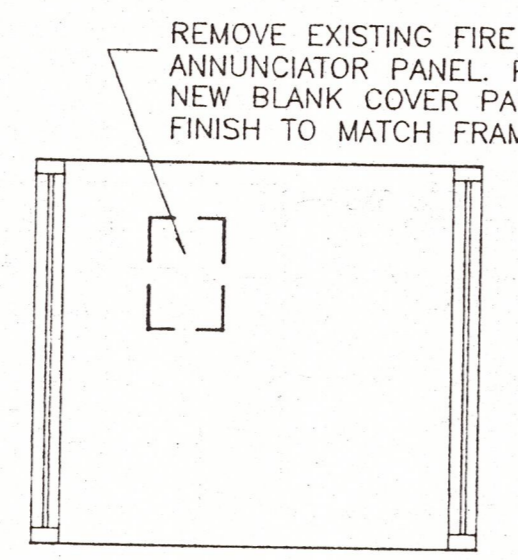

2 INTERIOR ELEVATION  
A12 SCALE: 1/4" = 1'-0"

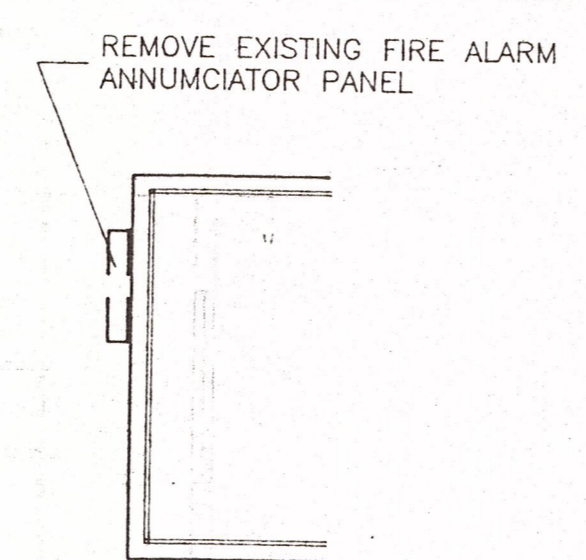


3 INTERIOR ELEVATION  
A12 SCALE: 1/4" = 1'-0"

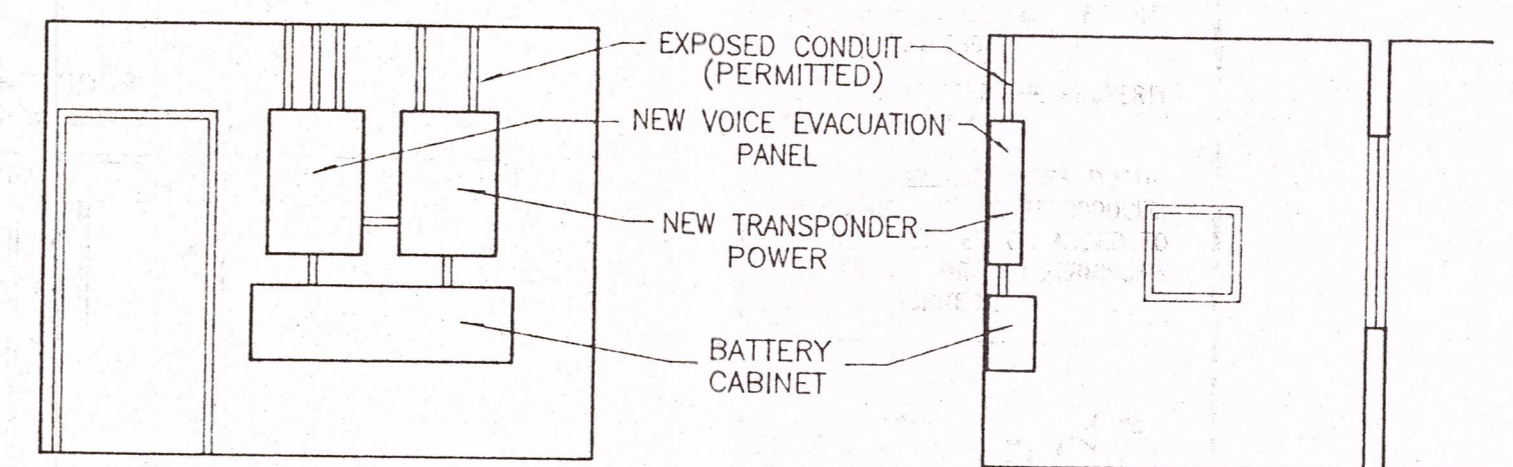


5 INTERIOR ELEVATION  
A12 SCALE: 1/4" = 1'-0"


6 INTERIOR ELEVATION  
A12 SCALE: 1/4" = 1'-0"

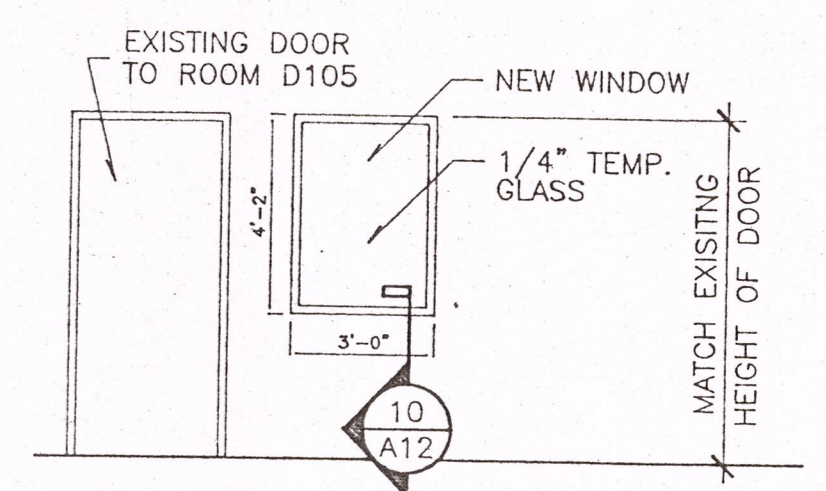


7 INTERIOR ELEVATION  
A12 SCALE: 1/4" = 1'-0"

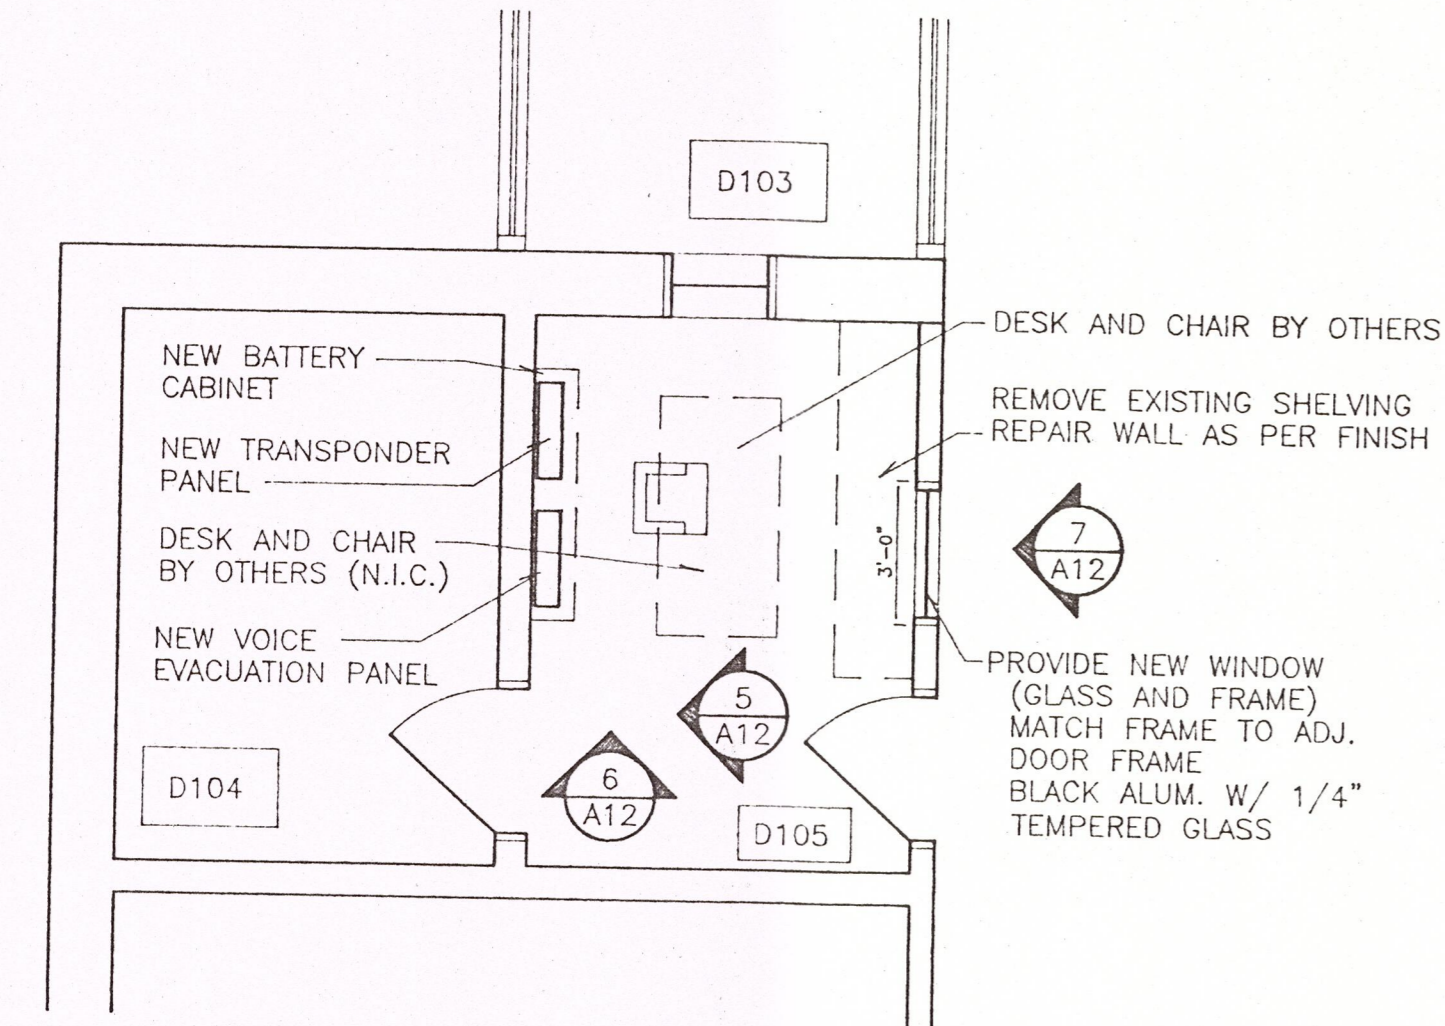


4 PARTIAL PLAN  
A12 SCALE: 1/4" = 1'-0"

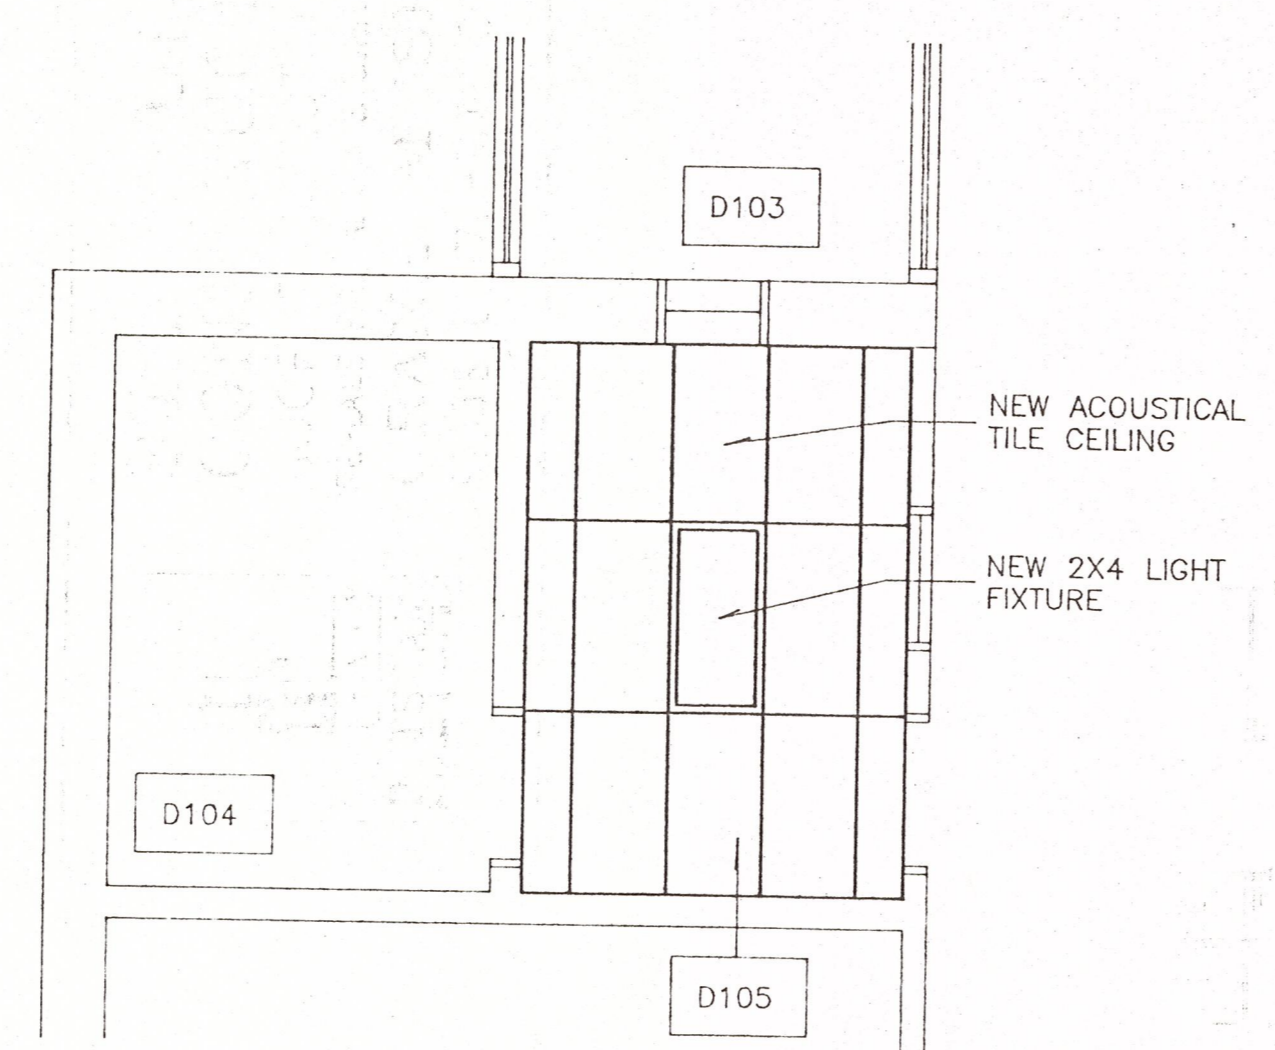

8 PARTIAL REFLECTED CEILING PLAN  
A12 SCALE: 1/4" = 1'-0"

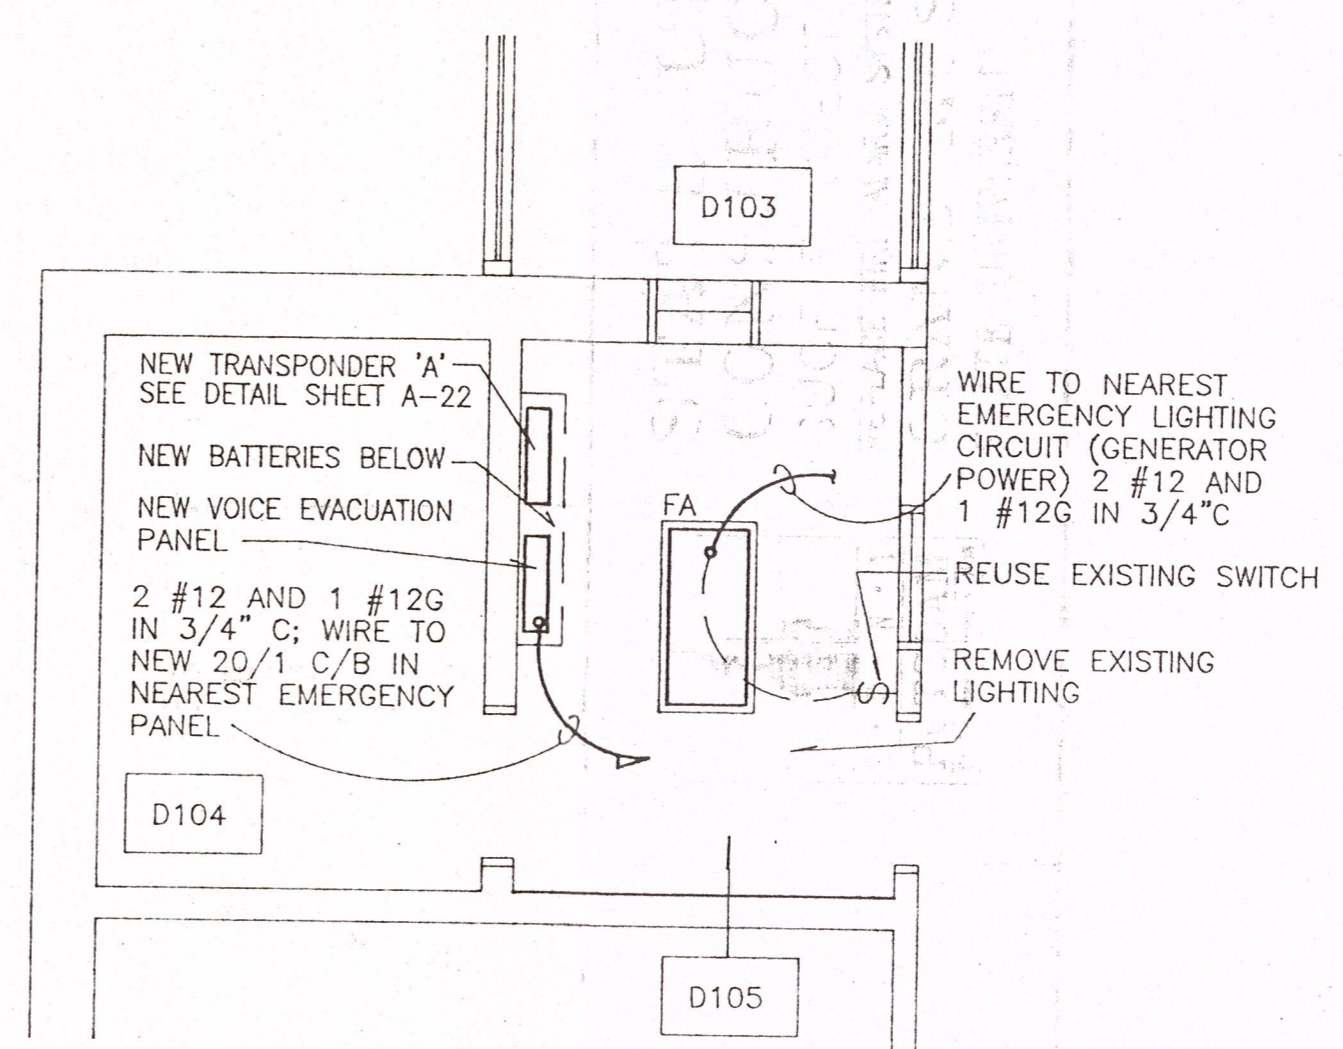

9 PARTIAL ELECTRICAL PLAN  
A12 SCALE: 1/4" = 1'-0"

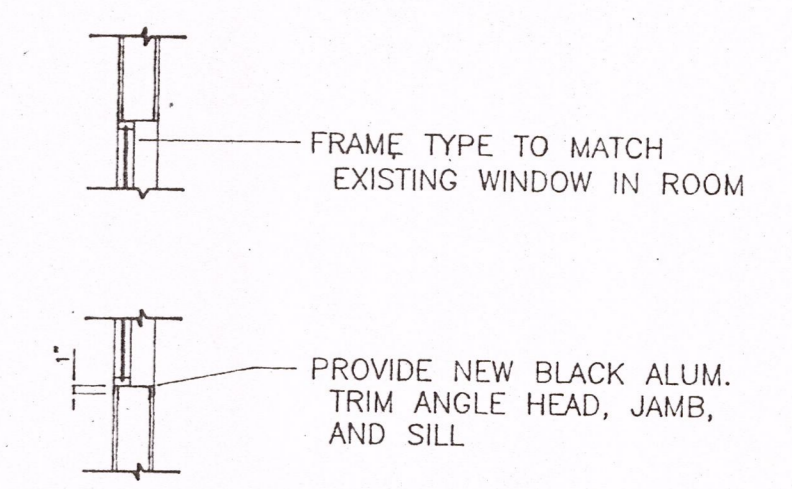

10 FIXED WINDOW SECTION  
A12 SCALE: 1/4" = 1'-0"



D14

FIXTURE SCHEDULE							
MARK	MAKE	MODEL	VOLTS	WATTS	LAMP		REMARKS
					TYPE	NO./FIXT.	
FA	DAYBRIGHT	DG232-RS 01	120	61	F3278/0 SP30	2	ELECTRONIC BALLAST
FB	PRESCOLITE	9H58	120	35	PL13	2	ELECTRONIC BALLAST

\* EQUIVALENT FIXTURES BY LITHONIA OR COLUMBIA WILL BE ACCEPTABLE.

CONTRACTOR SHALL CHECK AND FIELD VERIFY ALL DIMENSIONS AND REPORT DISCREPANCIES TO THE ARCHITECT BEFORE ANY WORK IS COMMENCED.  
ALL DRAWINGS ARE THE PROPERTY OF THE ARCHITECT.  
THIS DESIGN AND THESE DOCUMENTS MAY NOT BE REPRODUCED, REUSED, ALTERED OR ADDED TO WITHOUT THE WRITTEN PERMISSION OF THE ARCHITECT.

STATE UNIVERSITY  
CONSTRUCTION FUND  
SUCF PROJECT NUMBER 12130  
REPLACE FIRE ALARM SYSTEM / INSTALL SPRINKLER  
CRANE MUSIC COMPLEX  
STATE UNIVERSITY COLLEGE AT POTSDAM

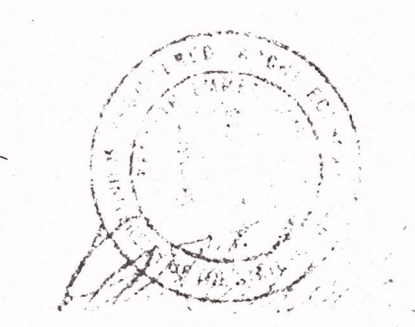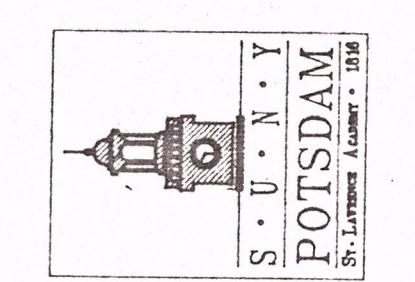

HAZEL CONSULTANTS IN ENGINEERING  
P.O. BOX 228  
CLIFTON PARK, NY 12065  
TEL: (518) 877-8566  
FAX: (518) 877-8599

OCM PROJECT NO. 10233

O'CONNOR & MARSH  
ARCHITECTS

FACILITY DESIGN - PLANNING

517 OVER THE LIBRARY  
WESTERN AVENUE  
ALBANY, NEW YORK 12203  
518 459 0611

DRAWING TITLE  
PARTIAL PLANS  
INTERIOR ELEVATIONS  
PARTIAL SECTIONS

DATE  
12-9-97  
DRAWING NO.  
A12  
SUCF PROJECT NO.  
12130

SNELL HALL (BLDG. NO. 9D)