




1 FIRST FLOOR - DUNN HALL
A16 NOT TO SCALE

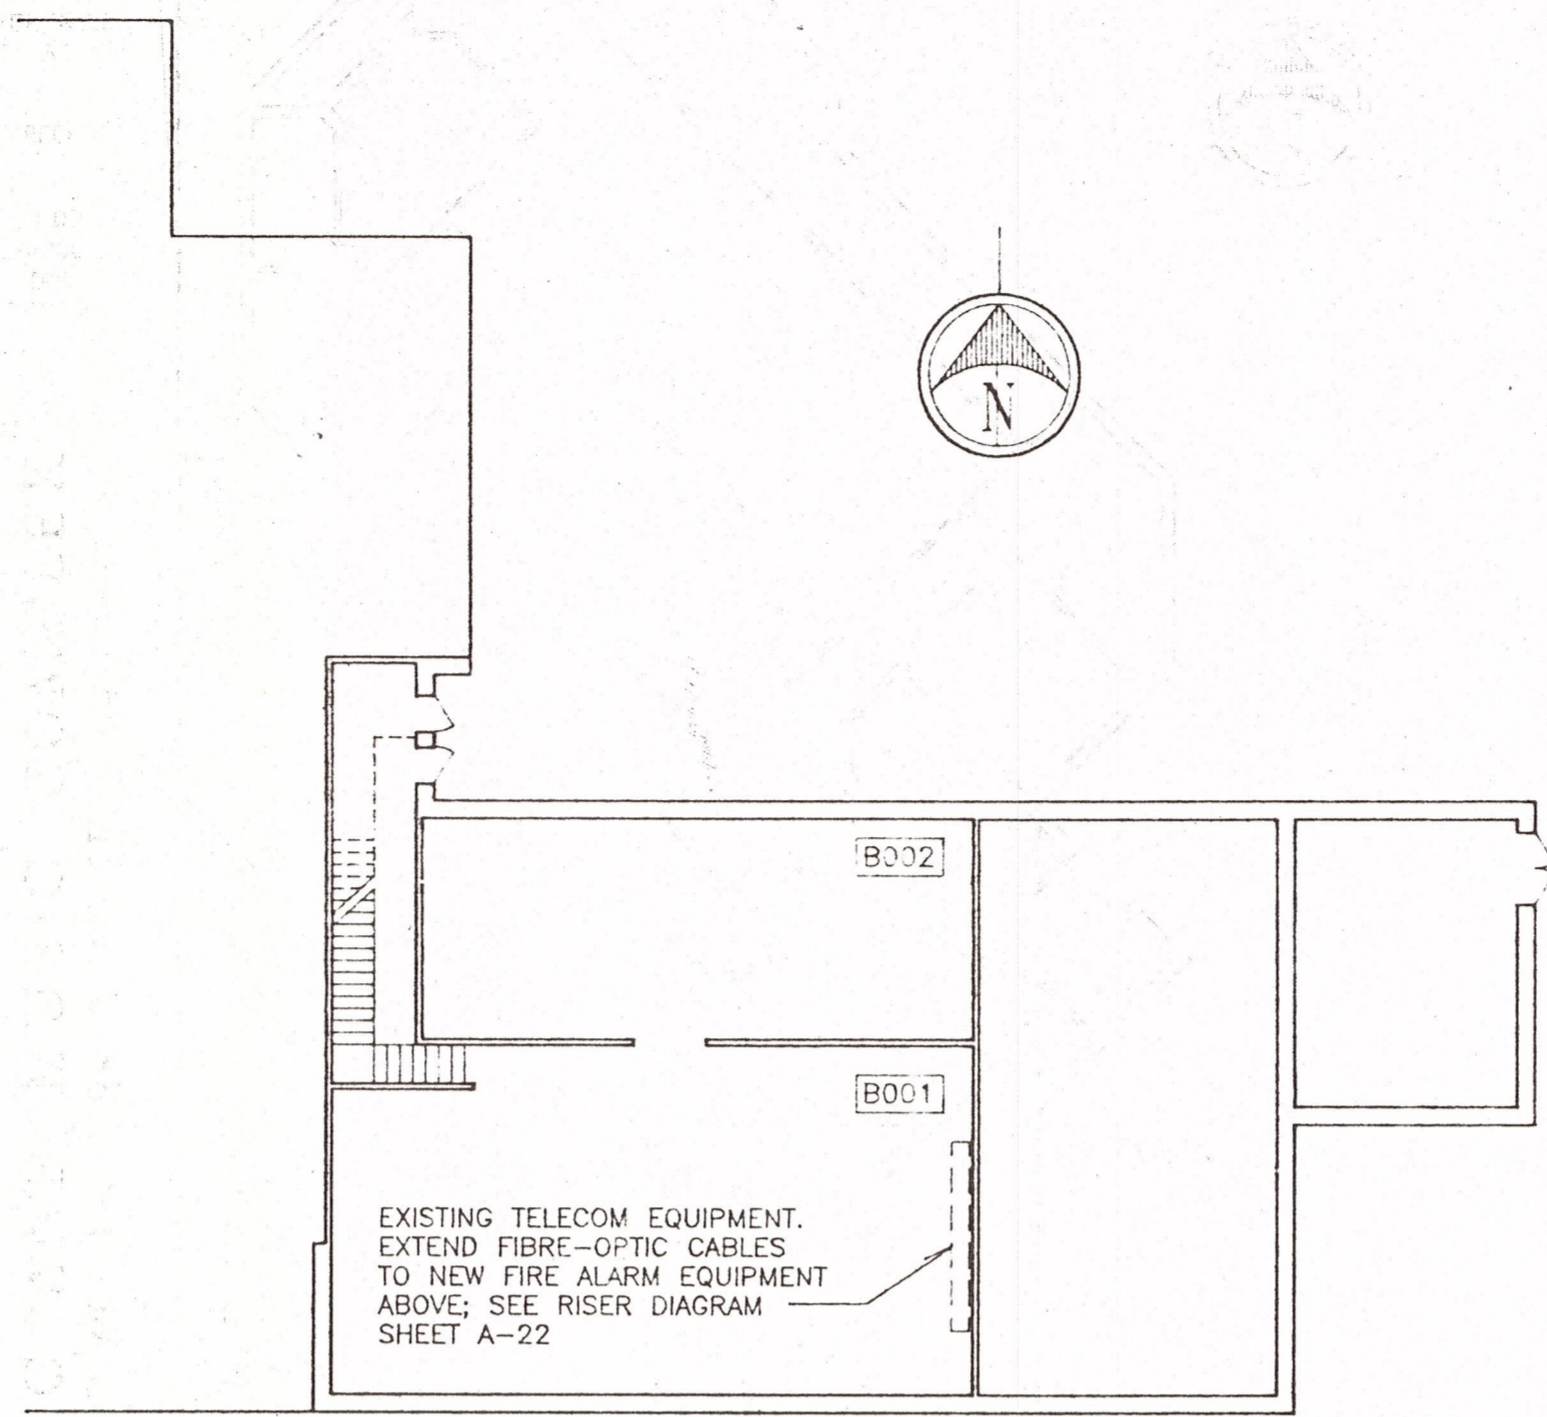


2 BASEMENT PLAN - DUNN HALL
A16 NOT TO SCALE

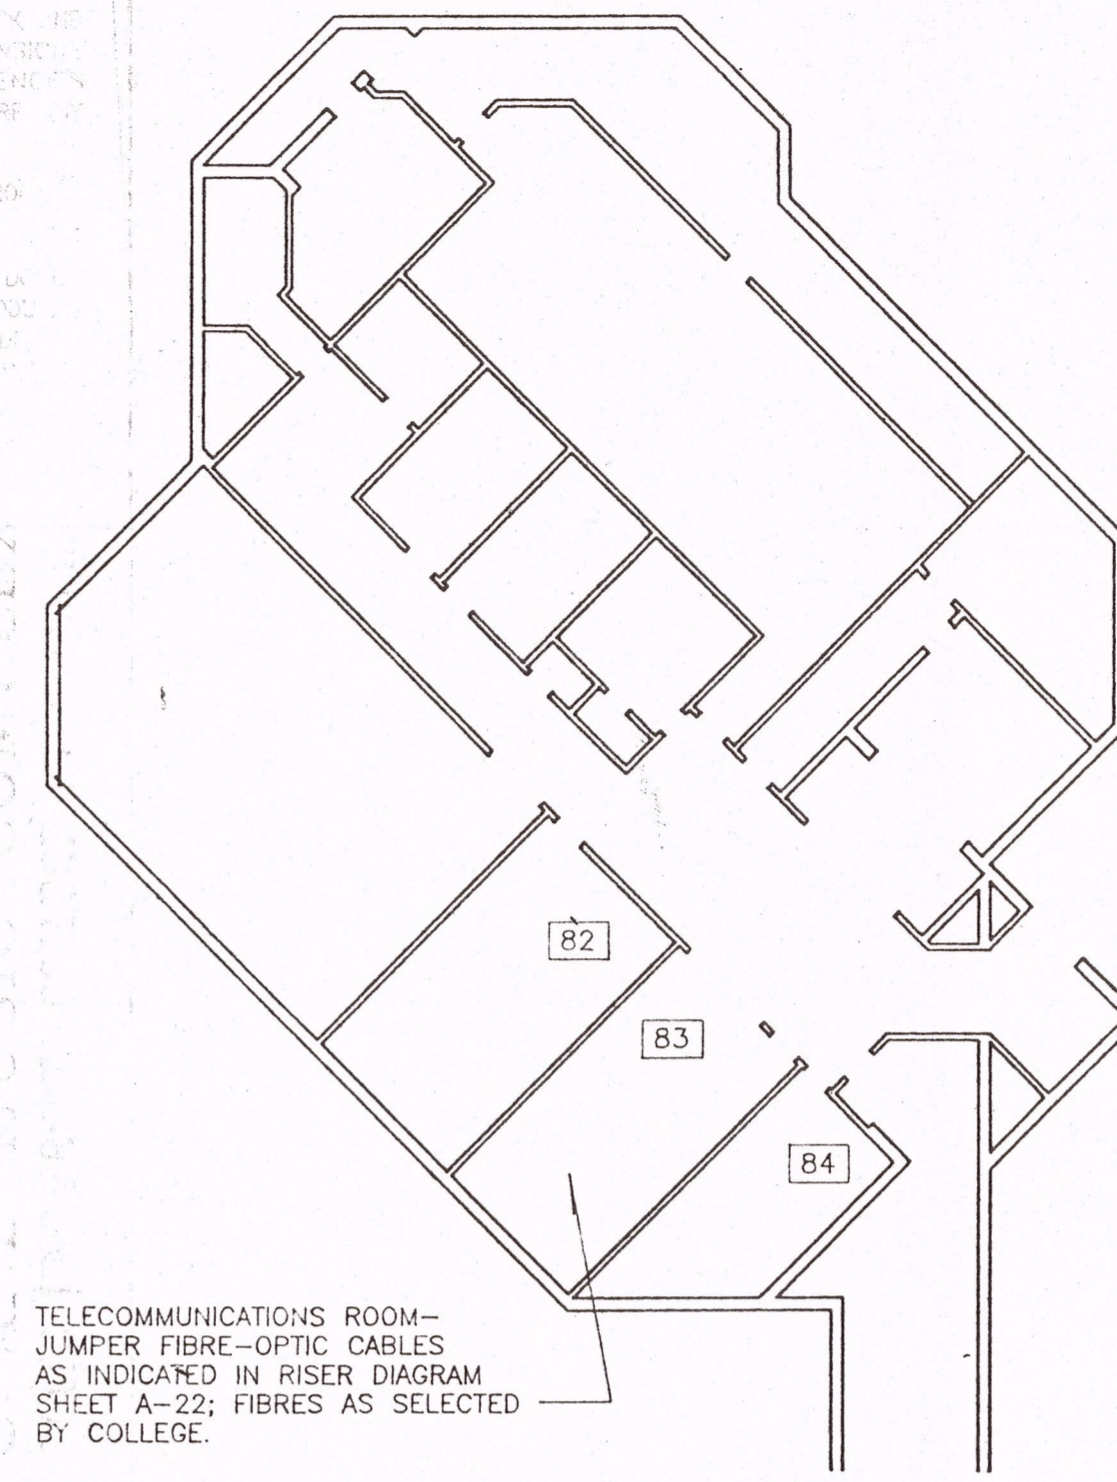


3 CELLAR PLAN - RAYMOND HALL
A16 NOT TO SCALE

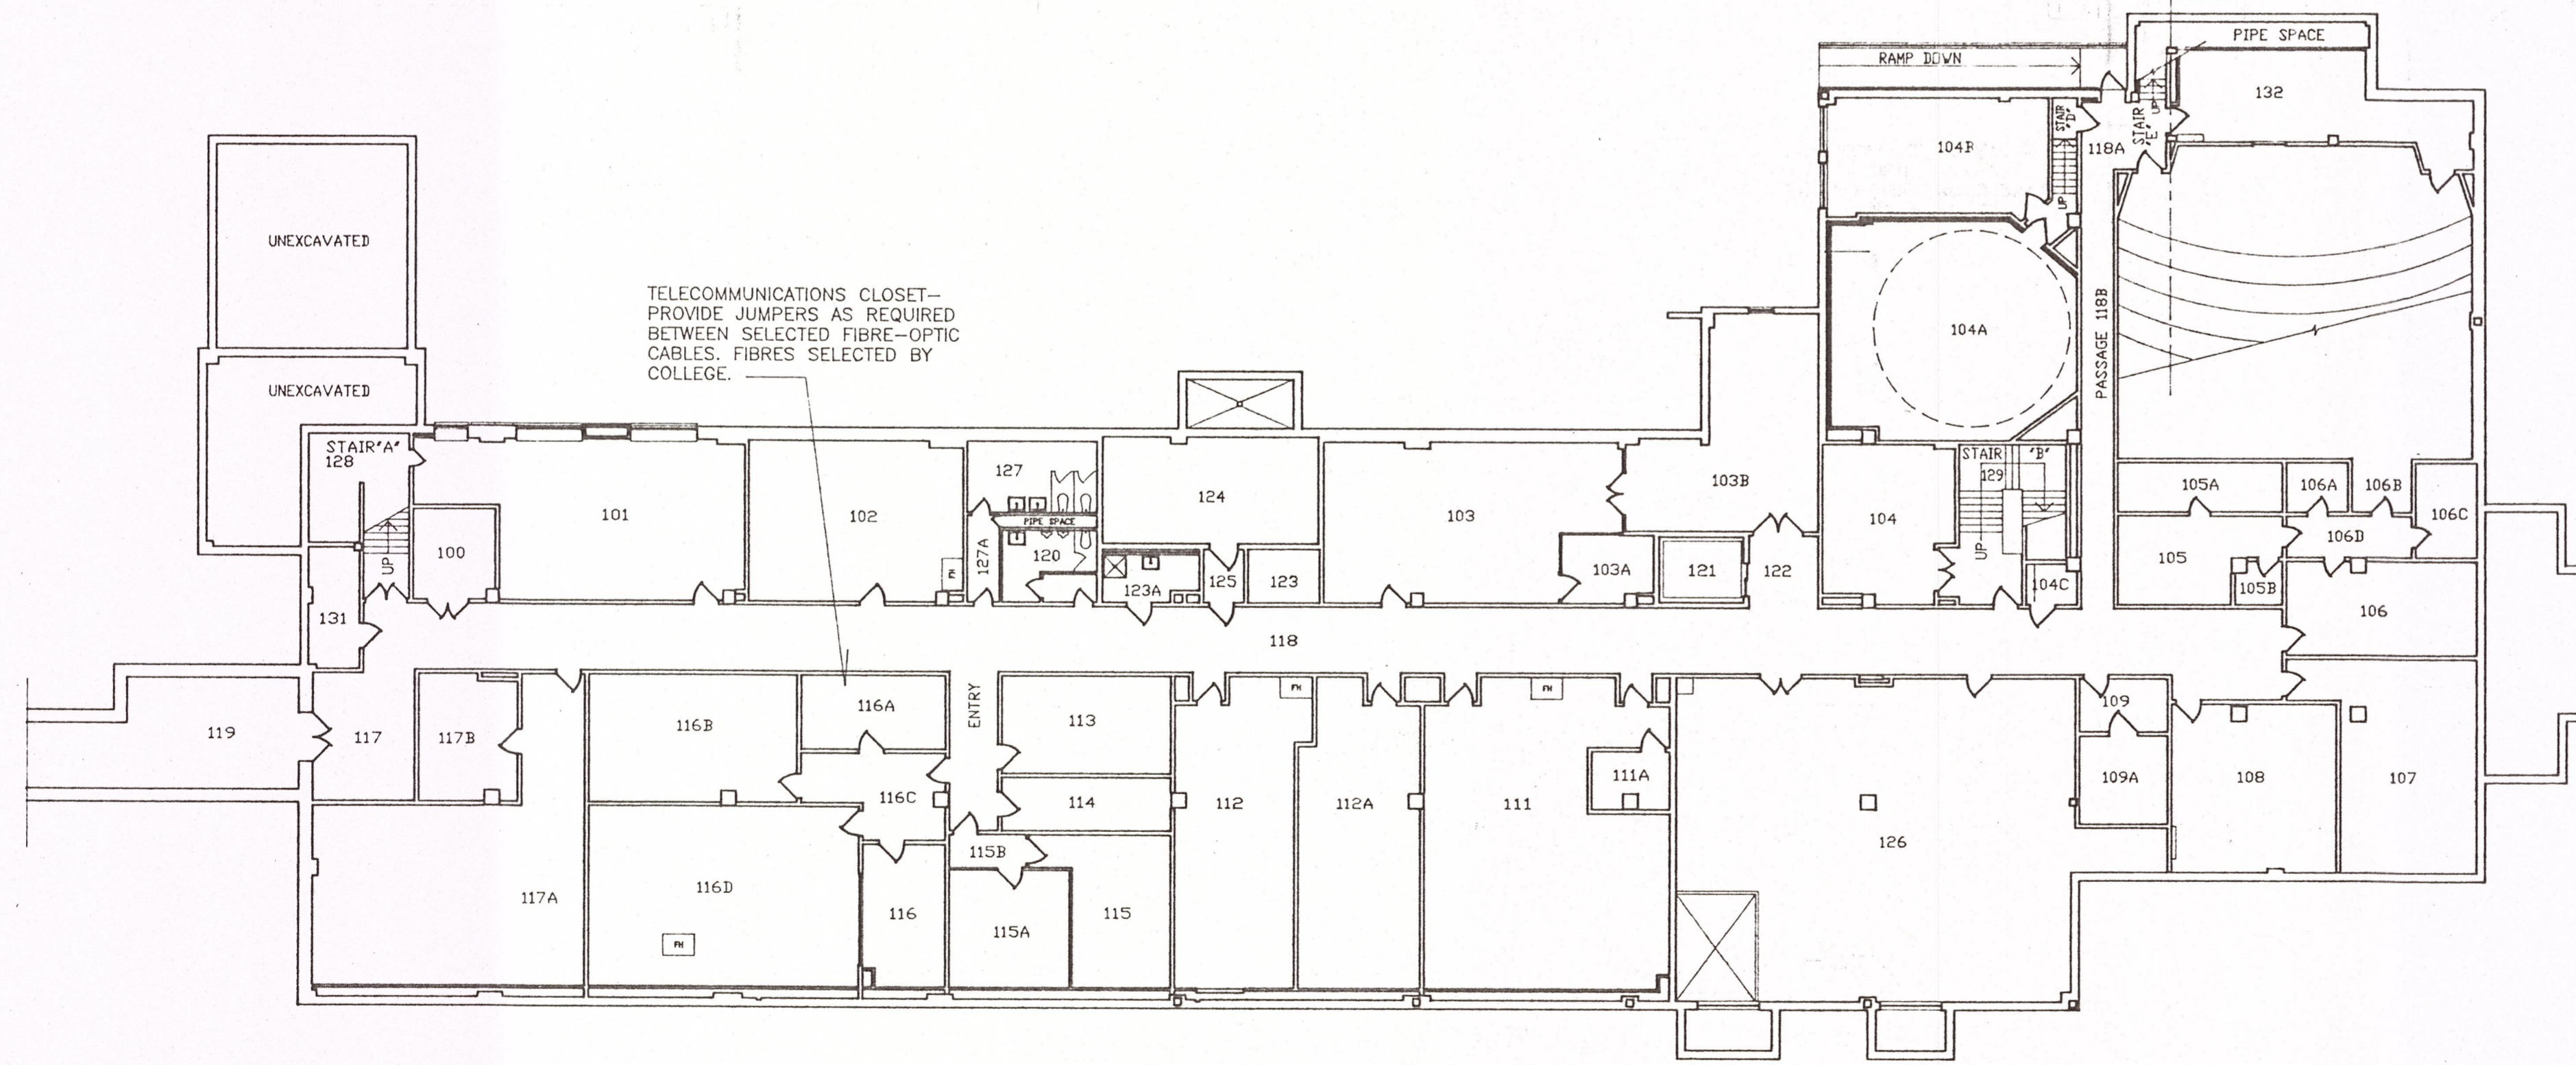

4 CELLAR PLAN - STOWELL HALL
A16 NOT TO SCALE

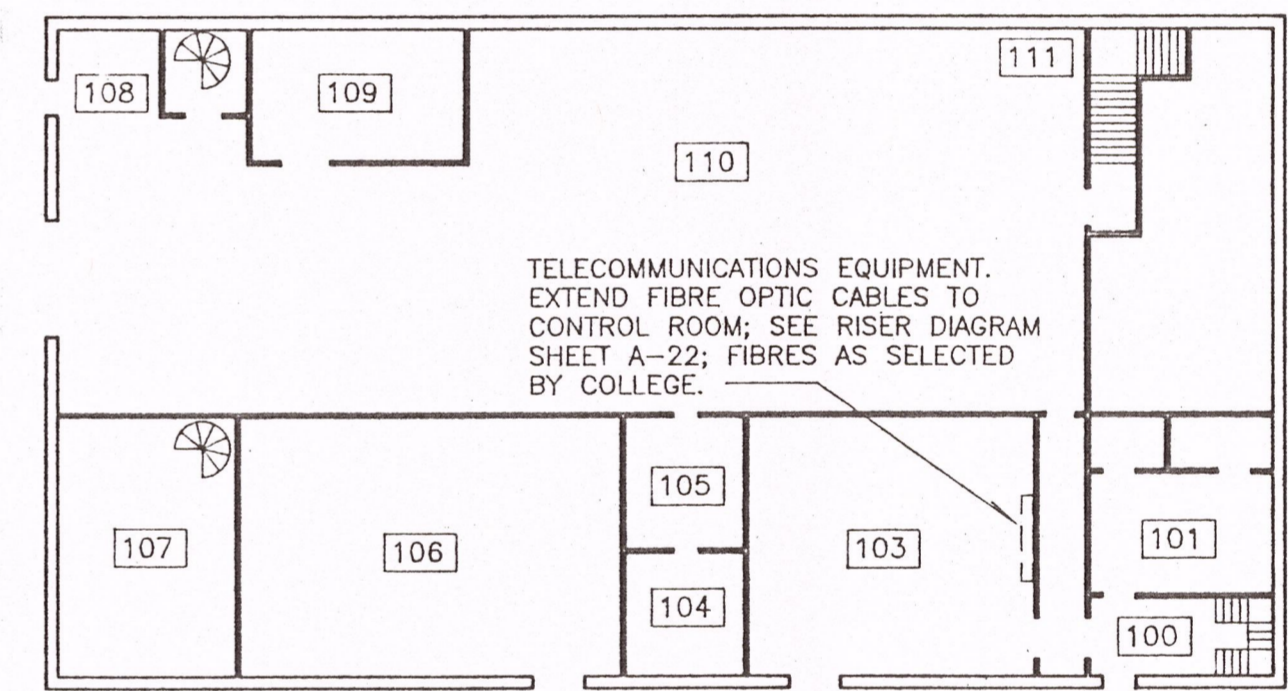



5 FIRST FLOOR - HEATING PLANT
A16 NOT TO SCALE

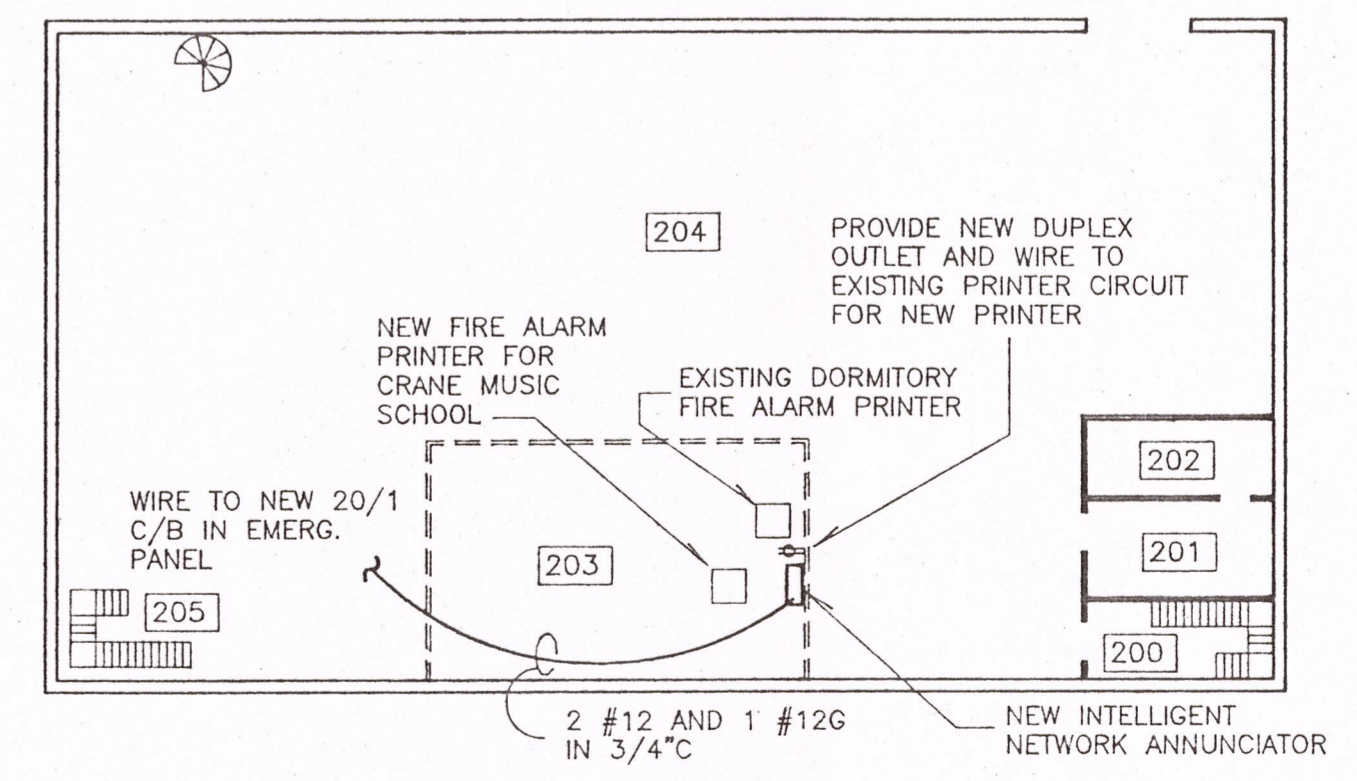

6 SECOND FLOOR - HEATING PLANT
A16 NOT TO SCALE

CONTRACTOR SHALL CHECK AND FIELD VERIFY ALL DIMENSIONS AND REPORT DISCREPANCIES TO THE ARCHITECT BEFORE ANY WORK IS COMMENCED.
ALL DRAWINGS ARE THE PROPERTY OF THE ARCHITECT.
THIS DESIGN AND THESE DOCUMENTS MAY NOT BE REPRODUCED, REUSED, ALTERED OR ADDED TO WITHOUT THE WRITTEN PERMISSION OF THE ARCHITECT.

STATE UNIVERSITY
CONSTRUCTION FUND
SUCF PROJECT NUMBER 12130
REPLACE FIRE ALARM SYSTEM / INSTALL SPRINKLER
CRANE MUSIC COMPLEX
STATE UNIVERSITY COLLEGE AT POTSDAM

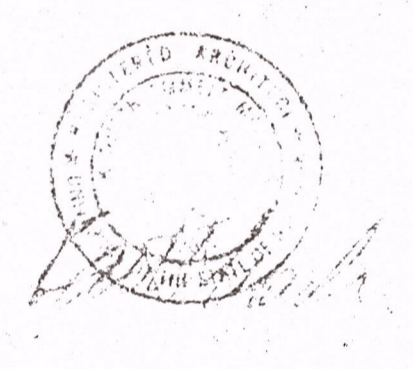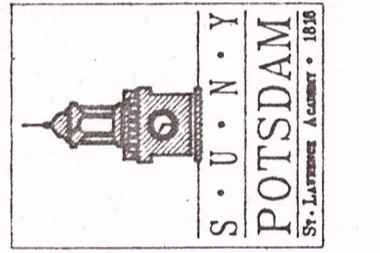

HAZF CONSULTANTS IN ENGINEERING
P.O. BOX 226
CLIFTON PARK, N.Y. 12065
TEL: (518) 877-8588
FAX: (518) 877-8589

OCM PROJECT NO. 10233

O'CONNOR & MARSH
ARCHITECTS

FACILITY DESIGN - PLANNING

517 OVER THE LIBRARY
WESTERN AVENUE
ALBANY, NEW YORK 12203
518 459 0611

DRAWING TITLE
PARTIAL PLANS -
DUNN HALL, STOWELL
HALL, RAYMOND HALL,
HEATING PLANT

DATE
12-9-97
DRAWING NO.
A16
SUCF PROJECT NO.
12130

D132