



2 PARTIAL ATTIC PLAN - LEVEL 2
A2 SCALE: 1/16" = 1'-0"

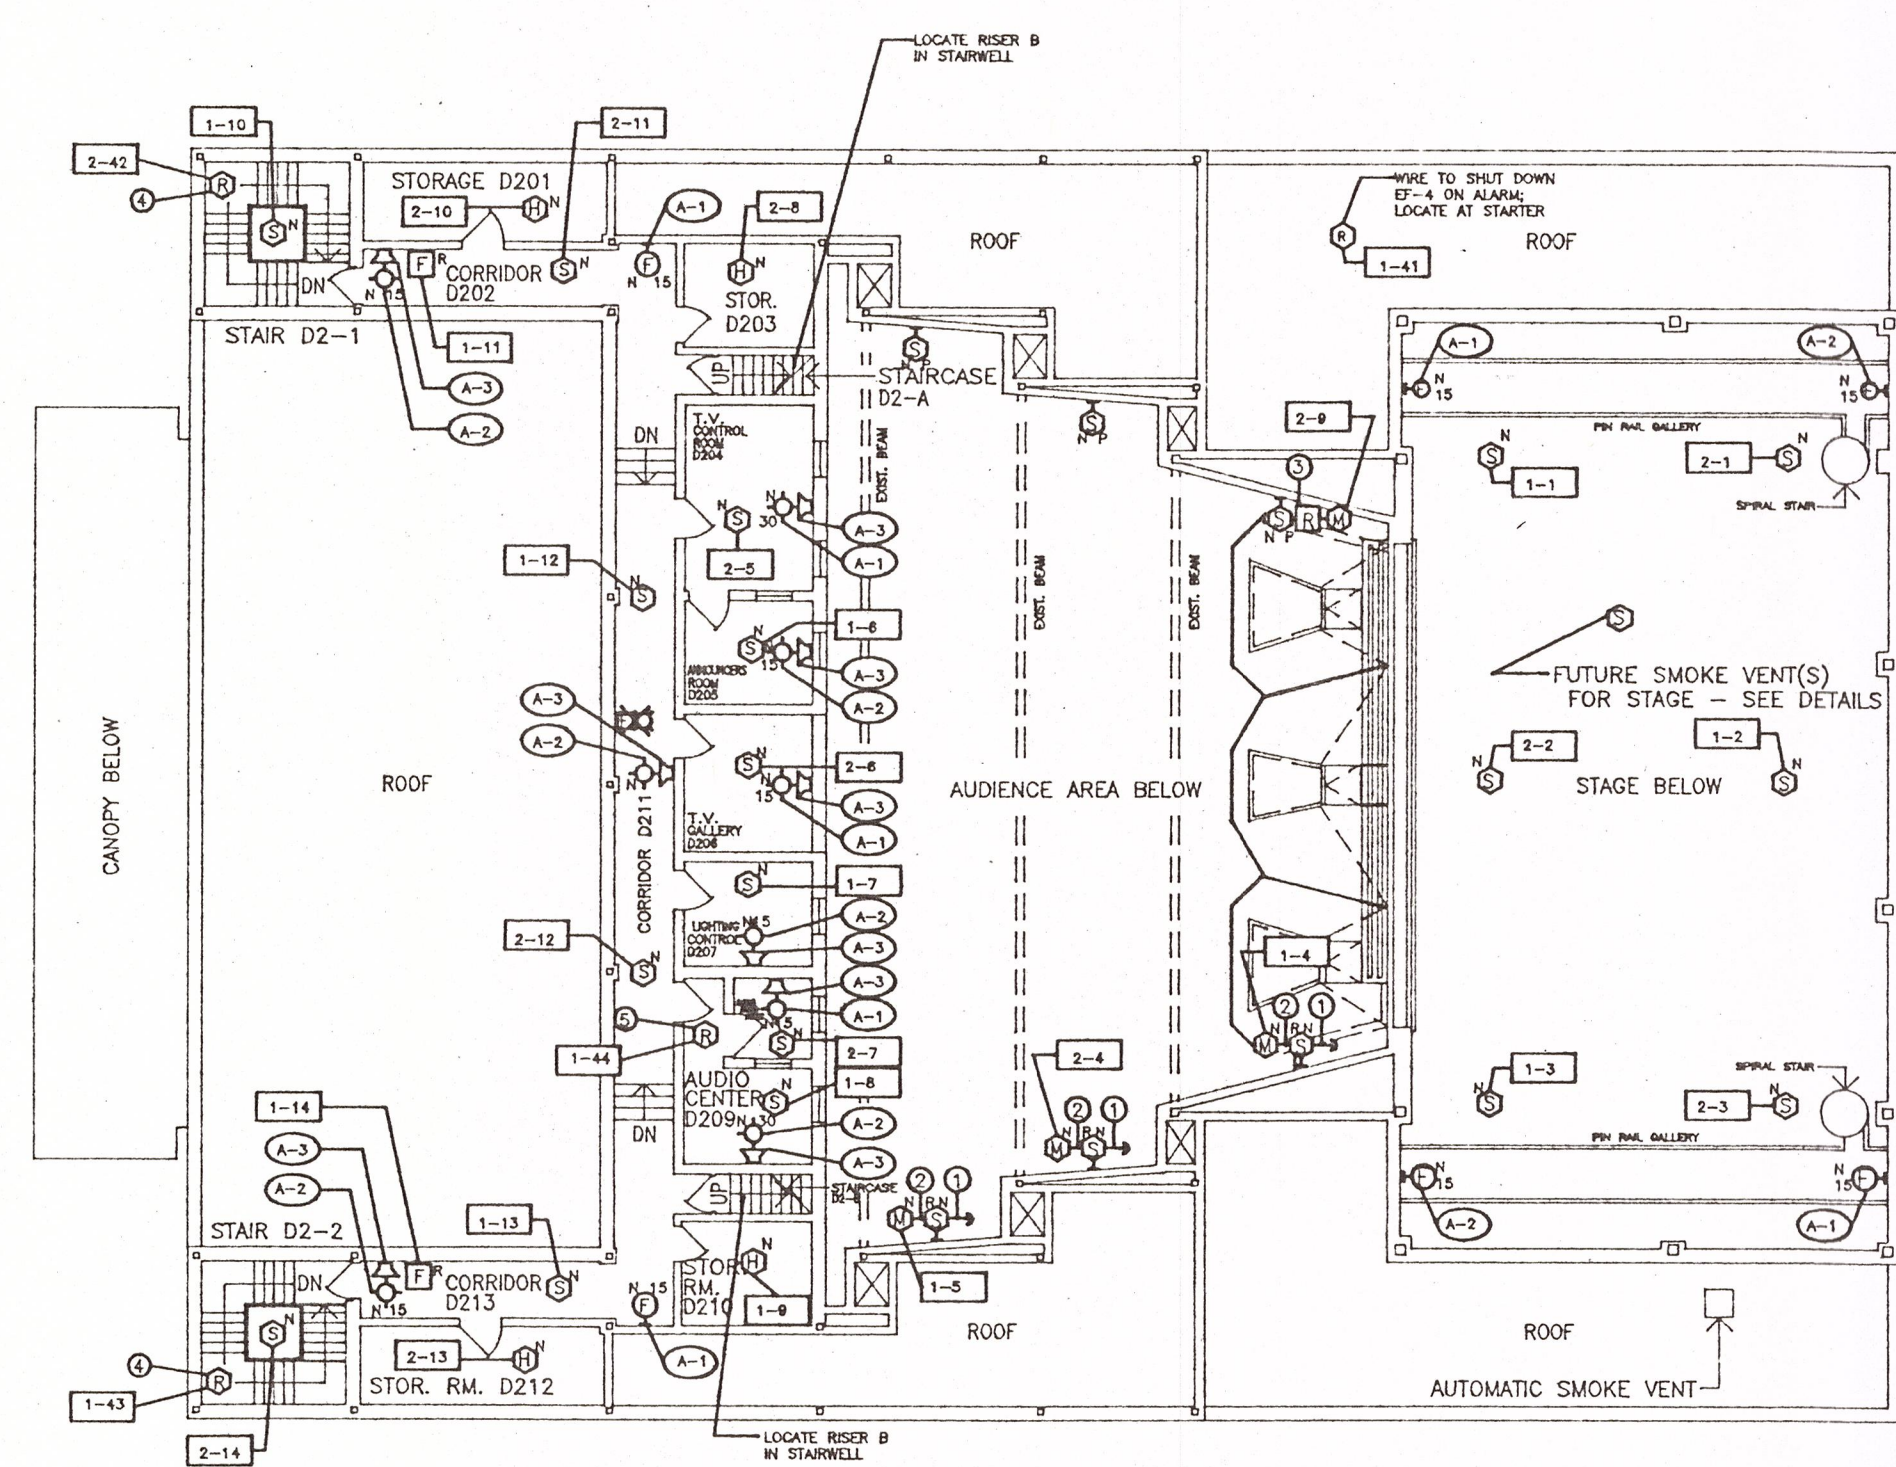

1 UPPER PLAN - LEVEL 2
A2 SCALE: 1/16" = 1'-0"

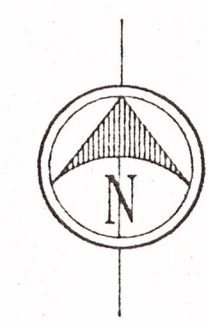


KEY NOTES:

- 1 DROP DOWN TO TEST STATION
- 2 WIRE BEAM DETECTOR RECEIVER TO ADDRESSABLE MONITOR MODULE. SEE DETAILS.
- 3 POWER SUPERVISORY RELAY FOR 24V DC TO BEAM SMOKE DETECTOR PROJECTORS. SEE DETAIL FOR WIRING TO MONITOR MODULE AND POWER SUPPLY.
- 4 FOR CONTROL OF FUTURE SMOKE RELIEF HATCH; SEE DETAIL
- 5 WIRE TO DISABLE SOUND SYSTEM ON ALARM - SEE DETAIL


CONTRACTOR SHALL CHECK AND FIELD VERIFY ALL DIMENSIONS AND REPORT DISCREPANCIES TO THE ARCHITECT BEFORE ANY WORK IS COMMENCED.
ALL DRAWINGS ARE THE PROPERTY OF THE ARCHITECT.
THIS DESIGN AND THESE DOCUMENTS MAY NOT BE REPRODUCED, REUSED, ALTERED OR ADDED TO WITHOUT THE WRITTEN PERMISSION OF THE ARCHITECT.

STATE UNIVERSITY
CONSTRUCTION FUND
SUCF PROJECT NUMBER 12130
REPLACE FIRE ALARM SYSTEM / INSTALL SPRINKLER
CRANE MUSIC COMPLEX
STATE UNIVERSITY COLLEGE AT POTSDAM

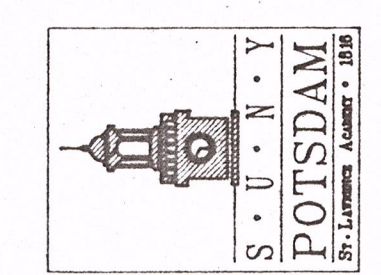

H&P CONSULTANTS IN ENGINEERING
P.O. BOX 226
CLIFTON PARK, N.Y. 12065
TEL: (518) 877-6506
FAX: (518) 877-6509

OCM PROJECT NO. 10233

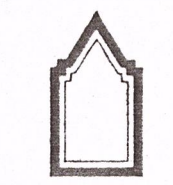

O'CONNOR & MARSH
ARCHITECTS


FACILITY DESIGN - PLANNING

517 OVER THE LIBRARY
WESTERN AVENUE
ALBANY, NEW YORK 12203
518 459 0611

DRAWING TITLE
SNELL HALL -
LEVEL 2 AND
PARTIAL ATTIC PLAN

DATE 12-9-97	DRAWING NO. A2
SUCF PROJECT NO. 12130	

KEY PLAN: CRANE MUSIC COMPLEX

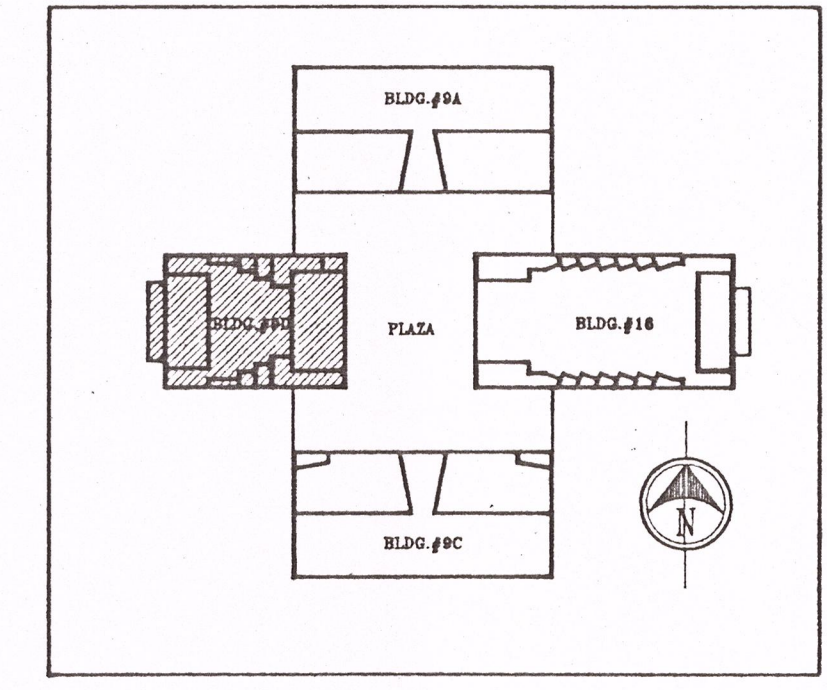

D116