




**ONE-LINE DIAGRAM - FIRE ALARM NETWORK**  
N.T.S.

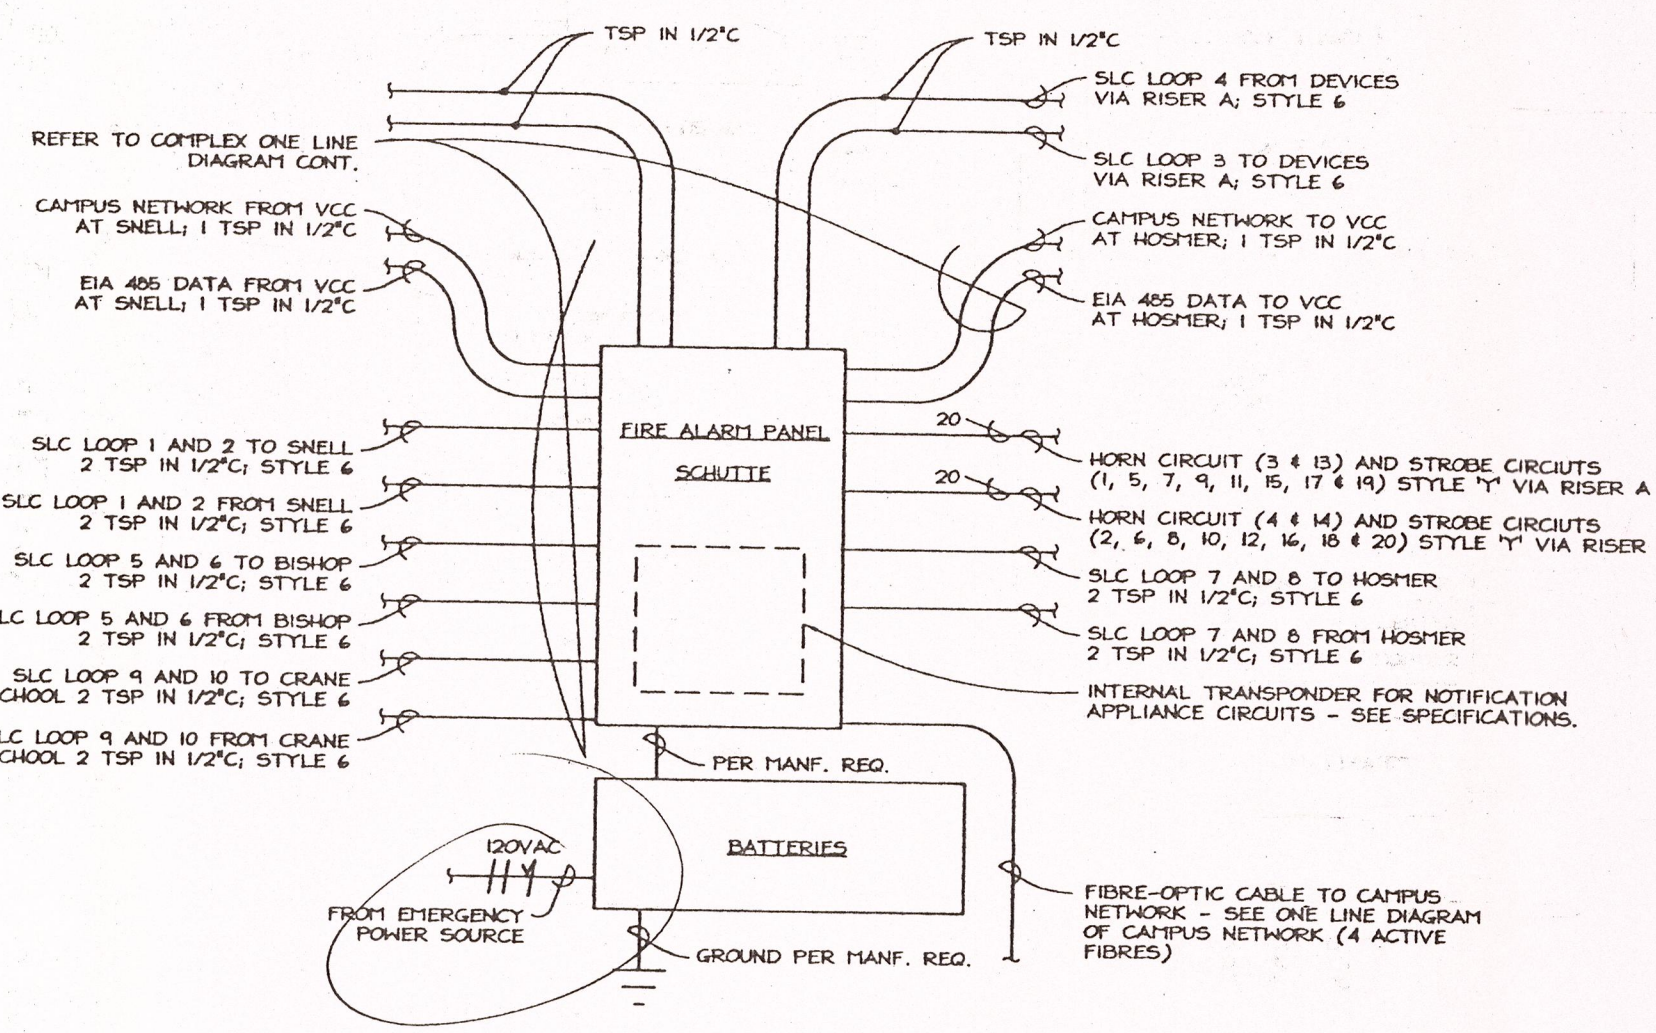


**DETAIL - FIRE ALARM PANEL**  
N.T.S.

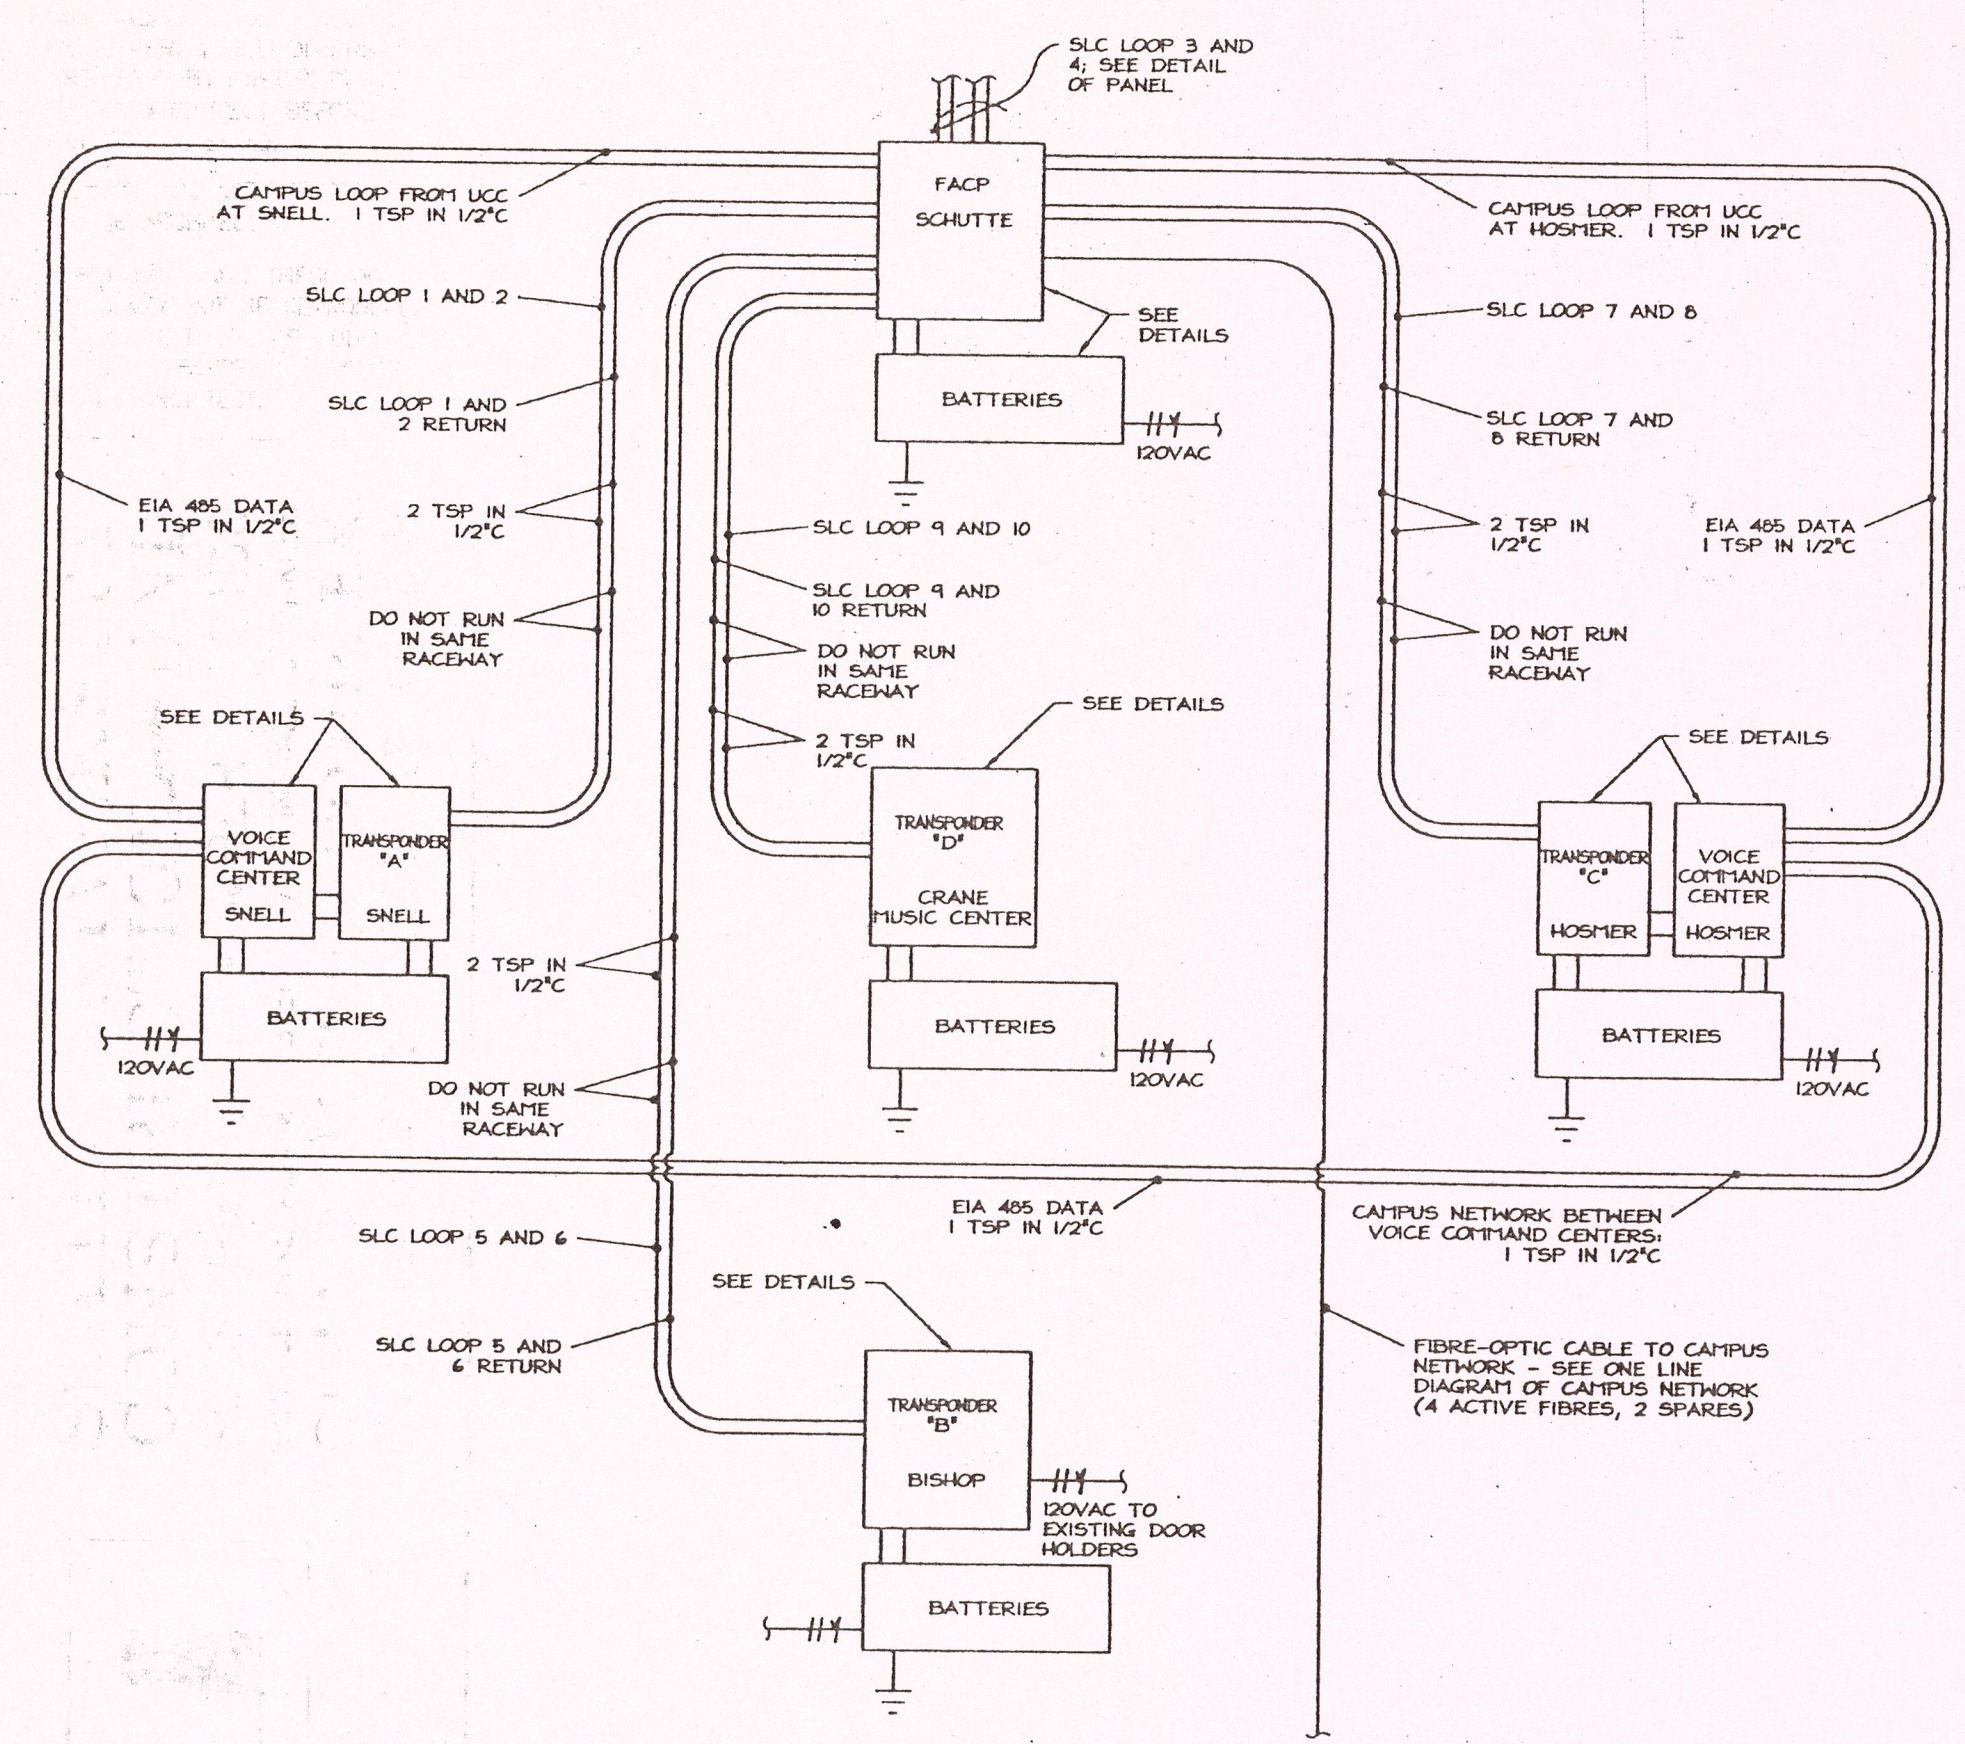


**ONE-LINE DIAGRAM - CRANE MUSIC FIRE ALARM**  
N.T.S.

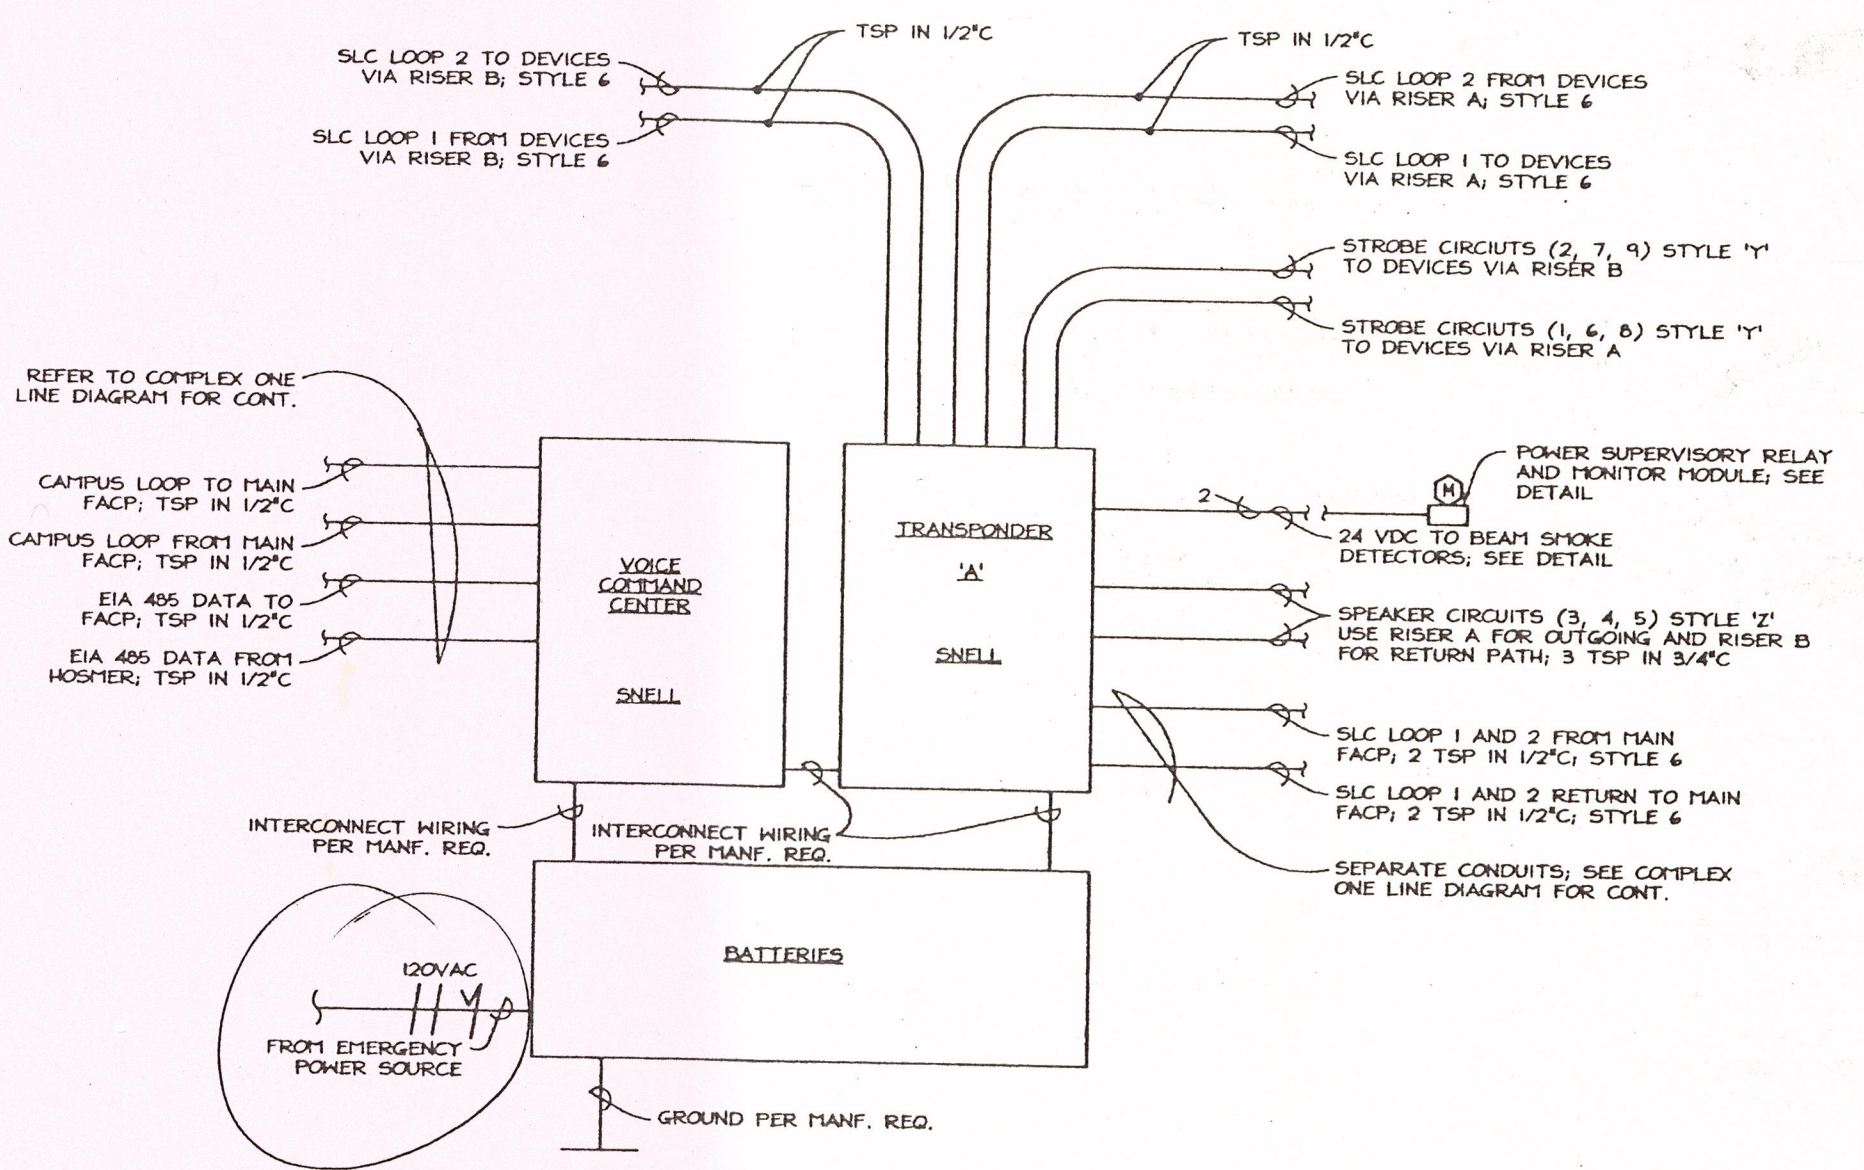


**DETAIL - TRANSPONDER 'A'**  
N.T.S.

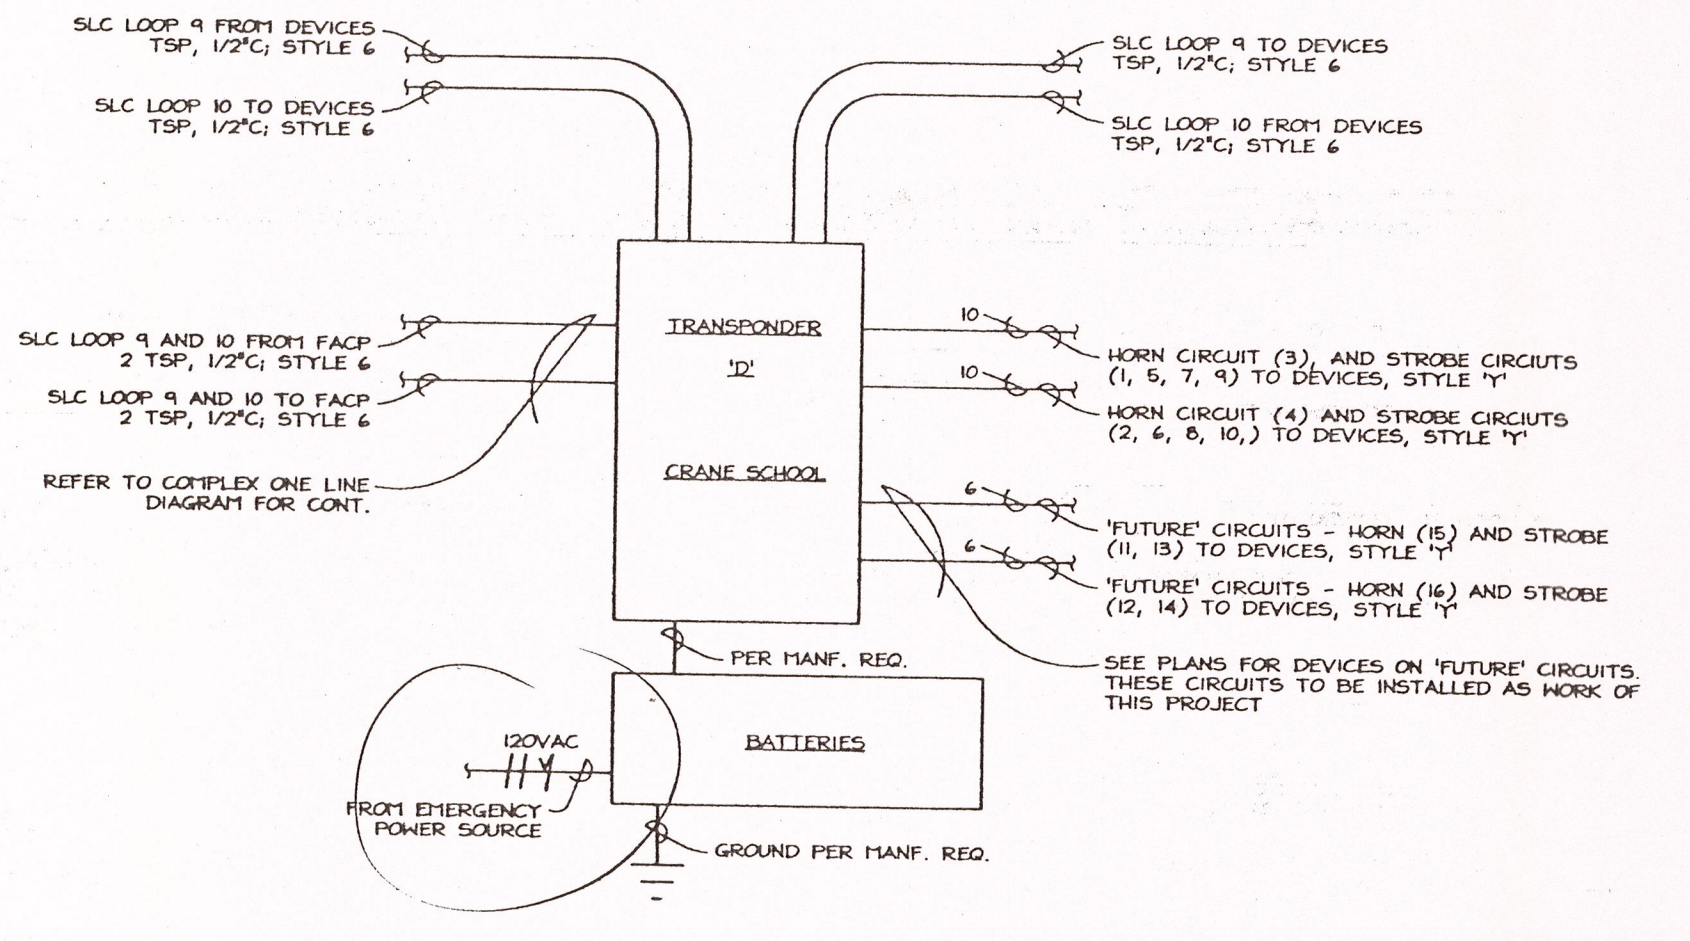


**DETAIL - TRANSPONDER 'D'**  
N.T.S.

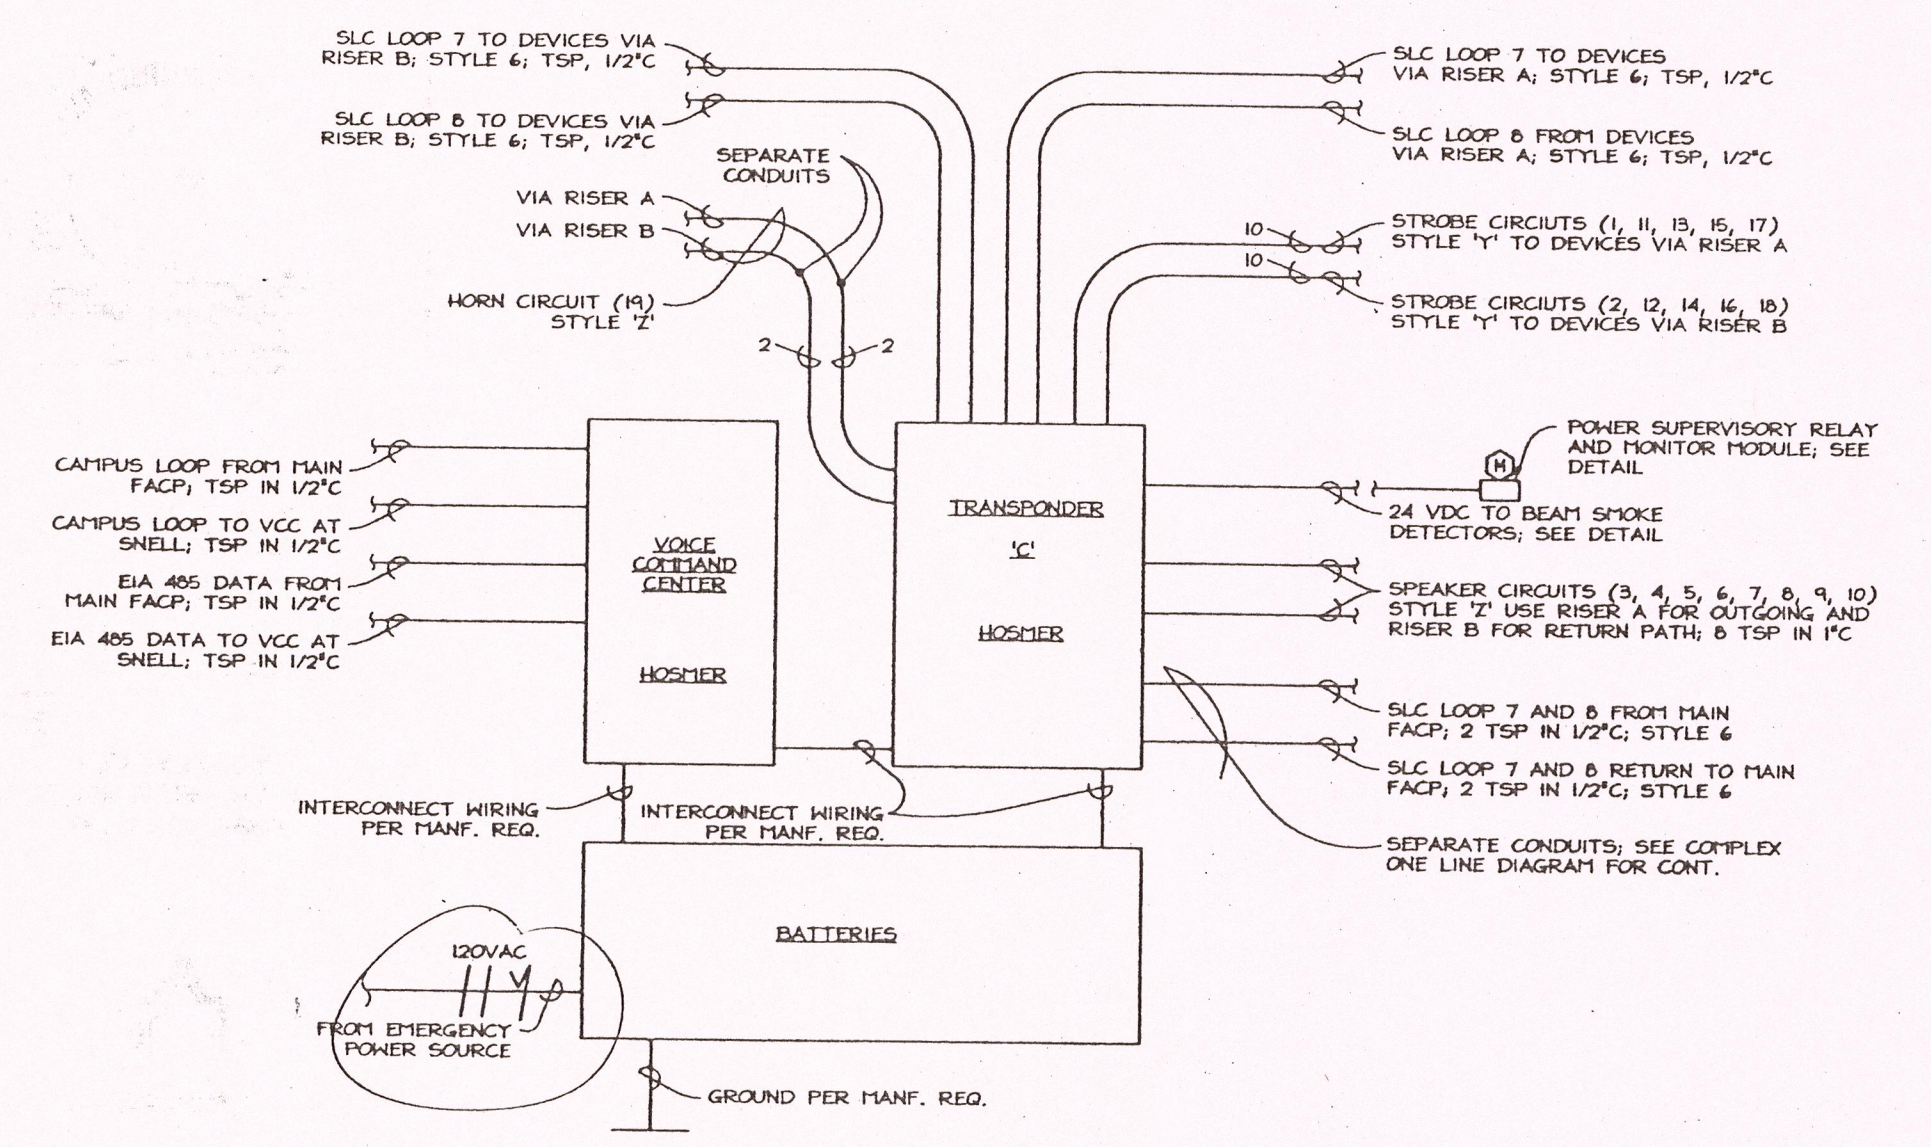


**DETAIL - TRANSPONDER 'C'**  
N.T.S.

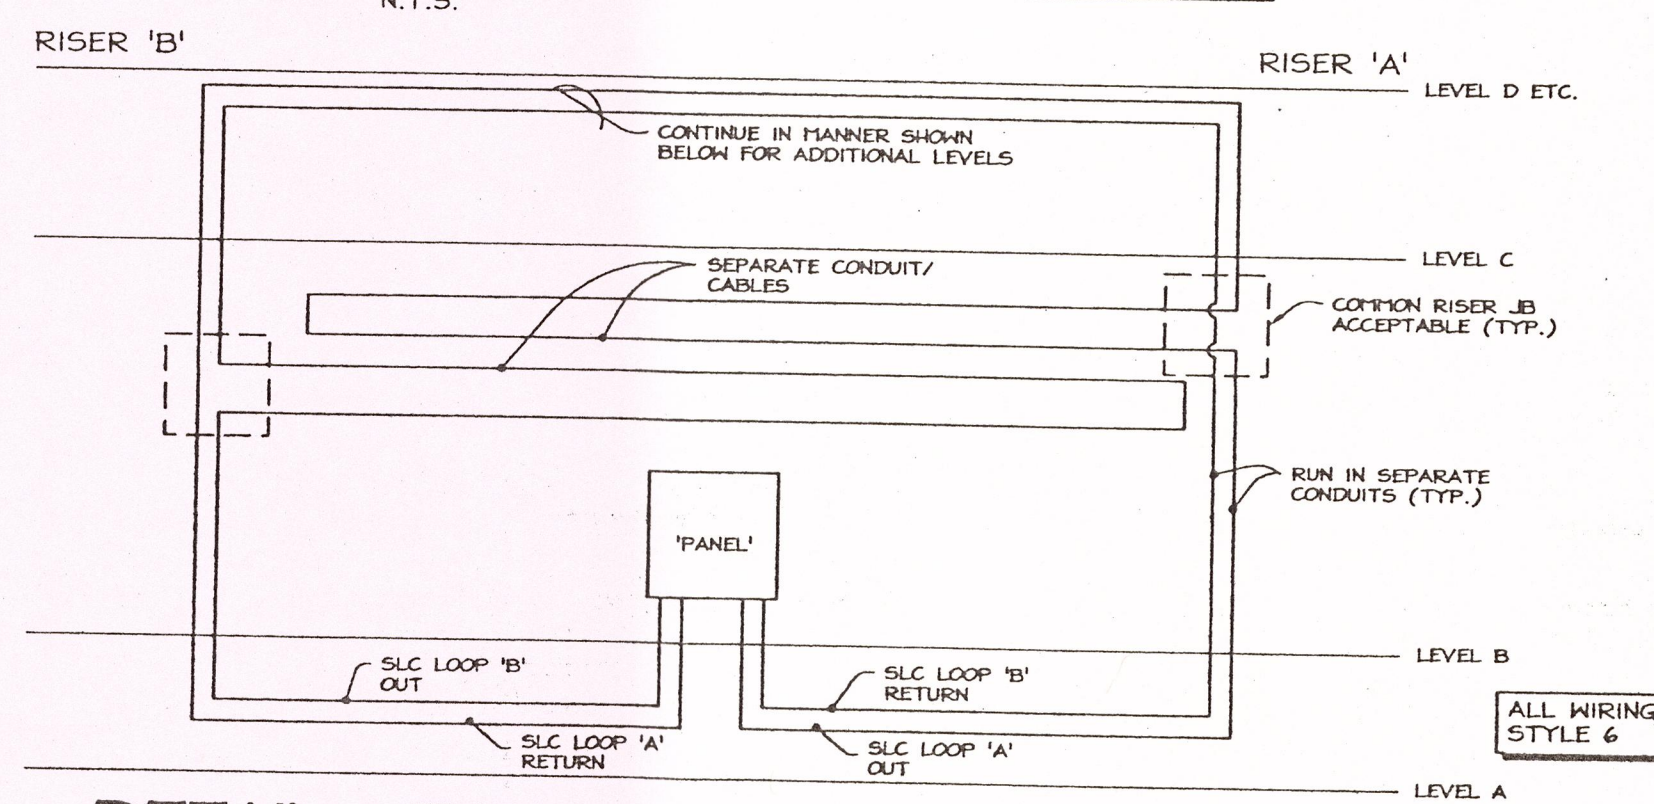

**DETAIL - TYPICAL SLC LOOP RISER ROUTING**  
N.T.S.

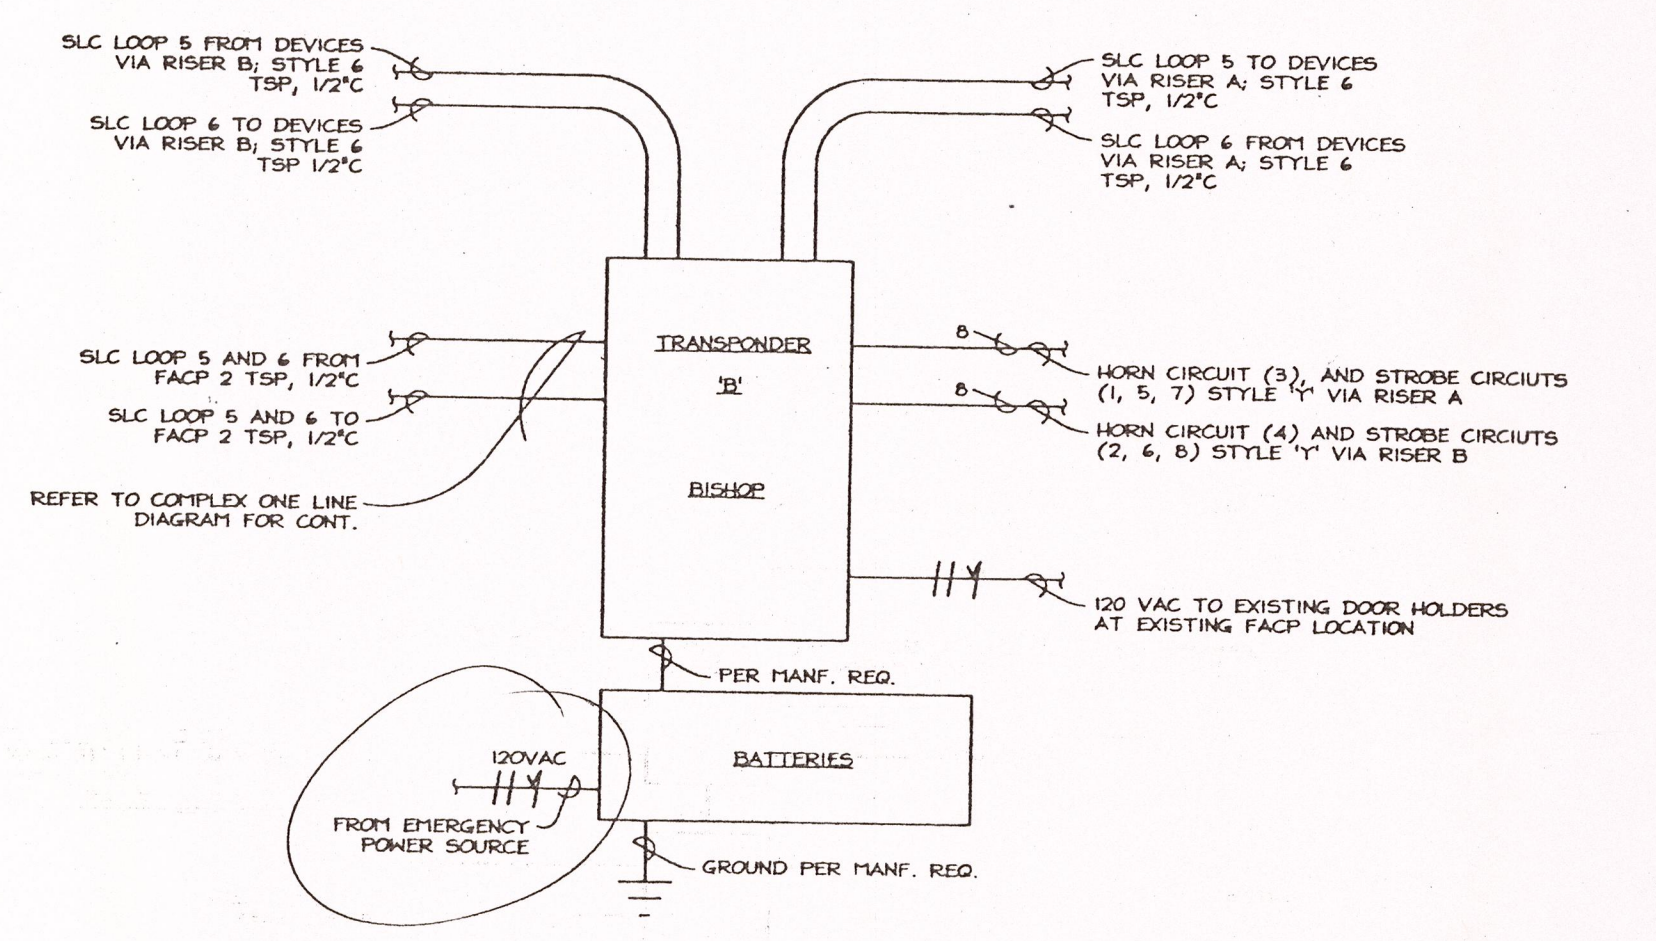

**DETAIL - TRANSPONDER 'B'**  
N.T.S.

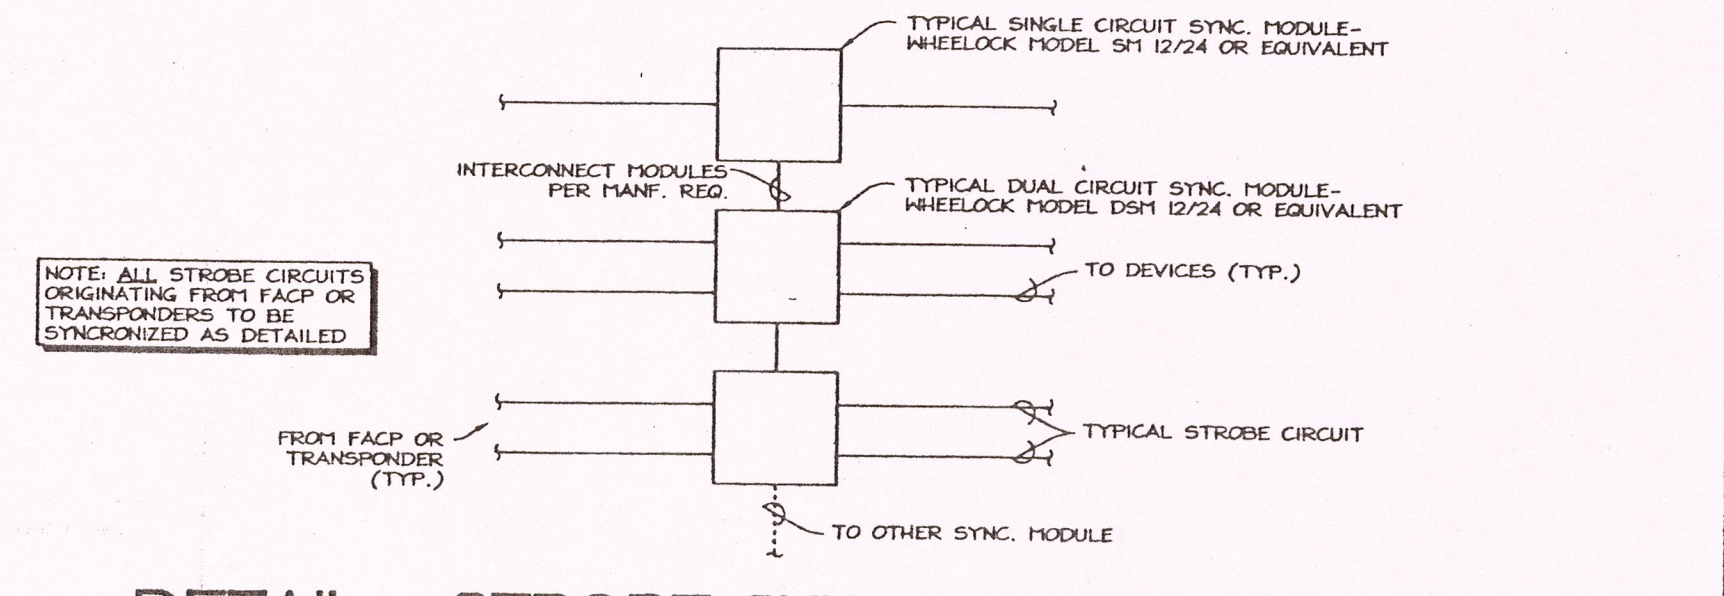



**DETAIL - STROBE SYNCHRONIZATION**  
N.T.S.

D116

EA95073VA22 8-5-97 100754 pn EST

CONTRACTOR SHALL CHECK AND FIELD VERIFY ALL DIMENSIONS AND REPORT DISCREPANCIES TO THE ARCHITECT BEFORE ANY WORK IS COMMENCED.  
ALL DRAWINGS ARE THE PROPERTY OF THE ARCHITECT.  
THIS DESIGN AND THESE DOCUMENTS MAY NOT BE REPRODUCED, REUSED, ALTERED OR ADDED TO WITHOUT THE WRITTEN PERMISSION OF THE ARCHITECT.

STATE UNIVERSITY  
CONSTRUCTION FUND  
SUCF PROJECT NUMBER 12130  
REPLACE FIRE ALARM SYSTEM / INSTALL SPRINKLER  
CRANE MUSIC COMPLEX  
STATE UNIVERSITY COLLEGE AT POTSDAM

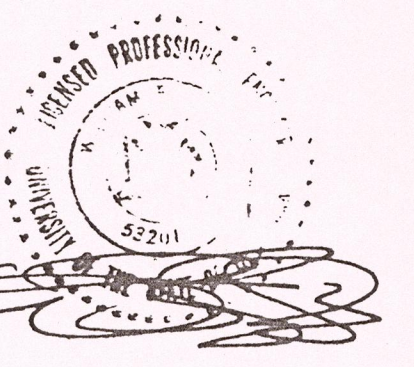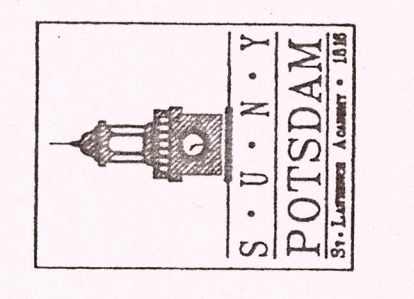

**HA2F CONSULTANTS IN ENGINEERING**  
P.O. BOX 226,  
CLIFTON PARK, NY 12065  
(518) 877-8566

**O'CONNOR & MARSH ARCHITECTS**  
FACILITY DESIGN - PLANNING

517 OVER THE LIBRARY  
WESTERN AVENUE  
ALBANY, NEW YORK 12203  
518 459 0611

DRAWING TITLE  
CRANE MUSIC COMPLEX -  
RISER DIAGRAMS  
AND DETAILS

DATE  
12-9-97  
DRAWING NO.  
A22  
SUCF PROJECT NO.  
12130