



SINGLE DETECTORS (SPRINKLER FLOW + VALVE SUPERVISION, CAR PRESSURE SIMILAR TO VALVE TAMPER.)

**DETAIL-WIRING OF THERMAL DETECTORS (SPRINKLER FLOW + SUPERVISION SIMILAR)**

N.T.S.

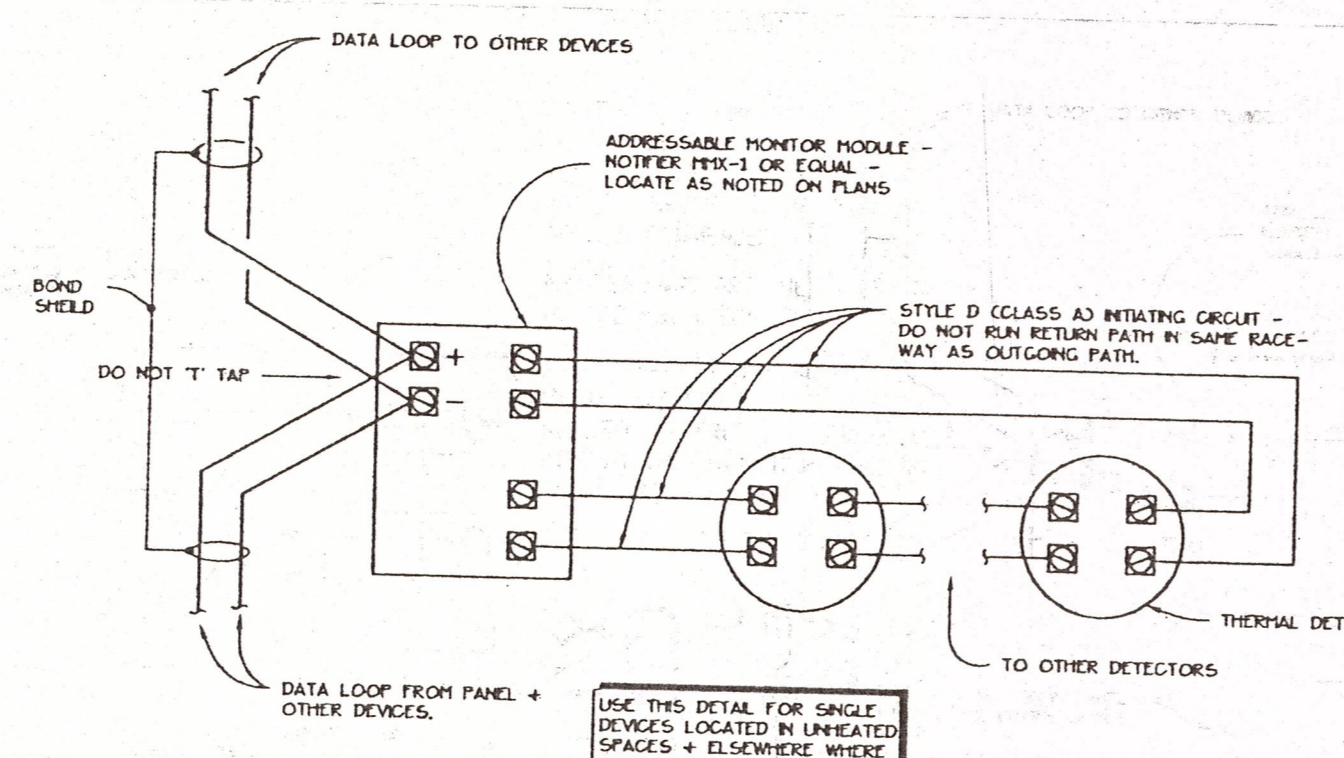


MULTIPLE DETECTORS

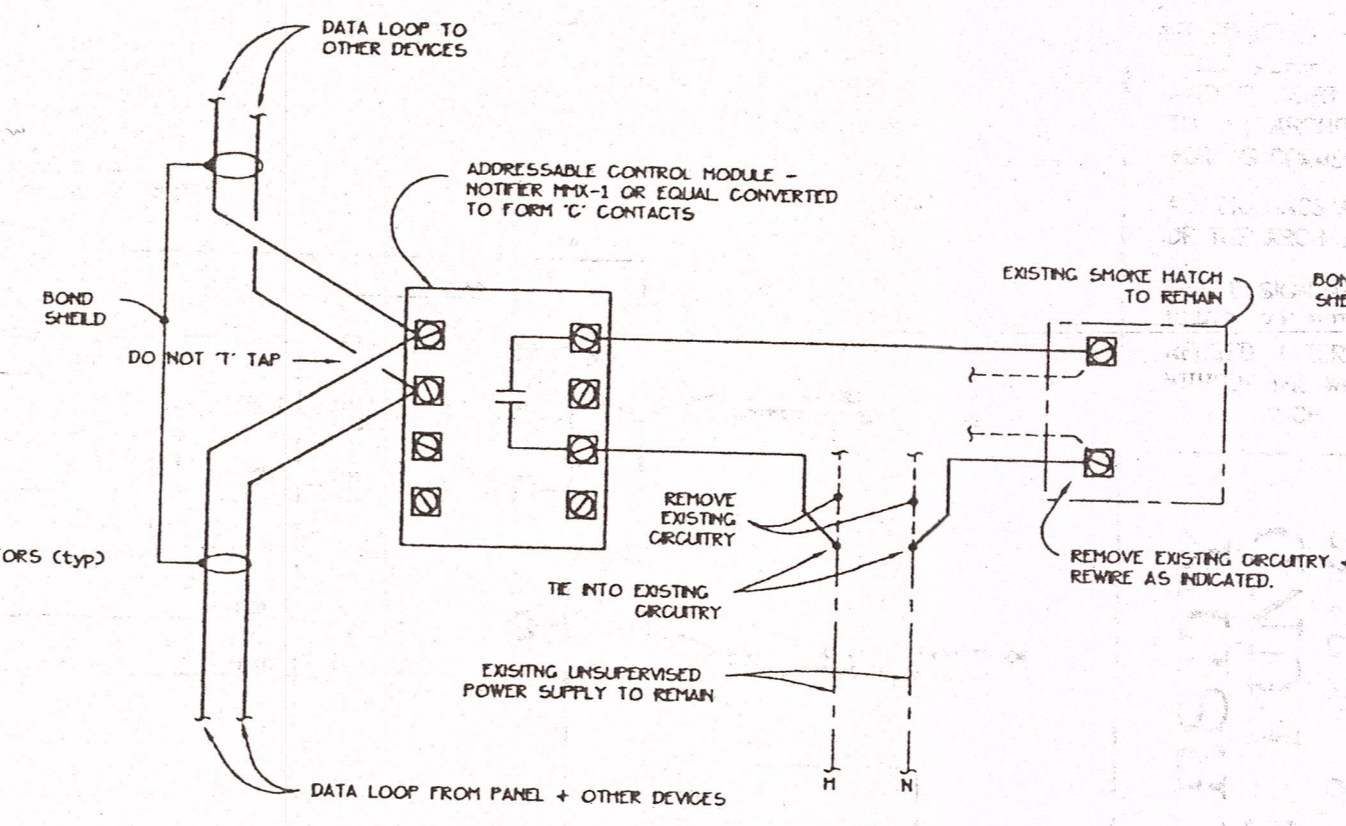


**DETAIL - SMOKE HATCH WIRING**

N.T.S. (GAS VALVE SIMILAR)

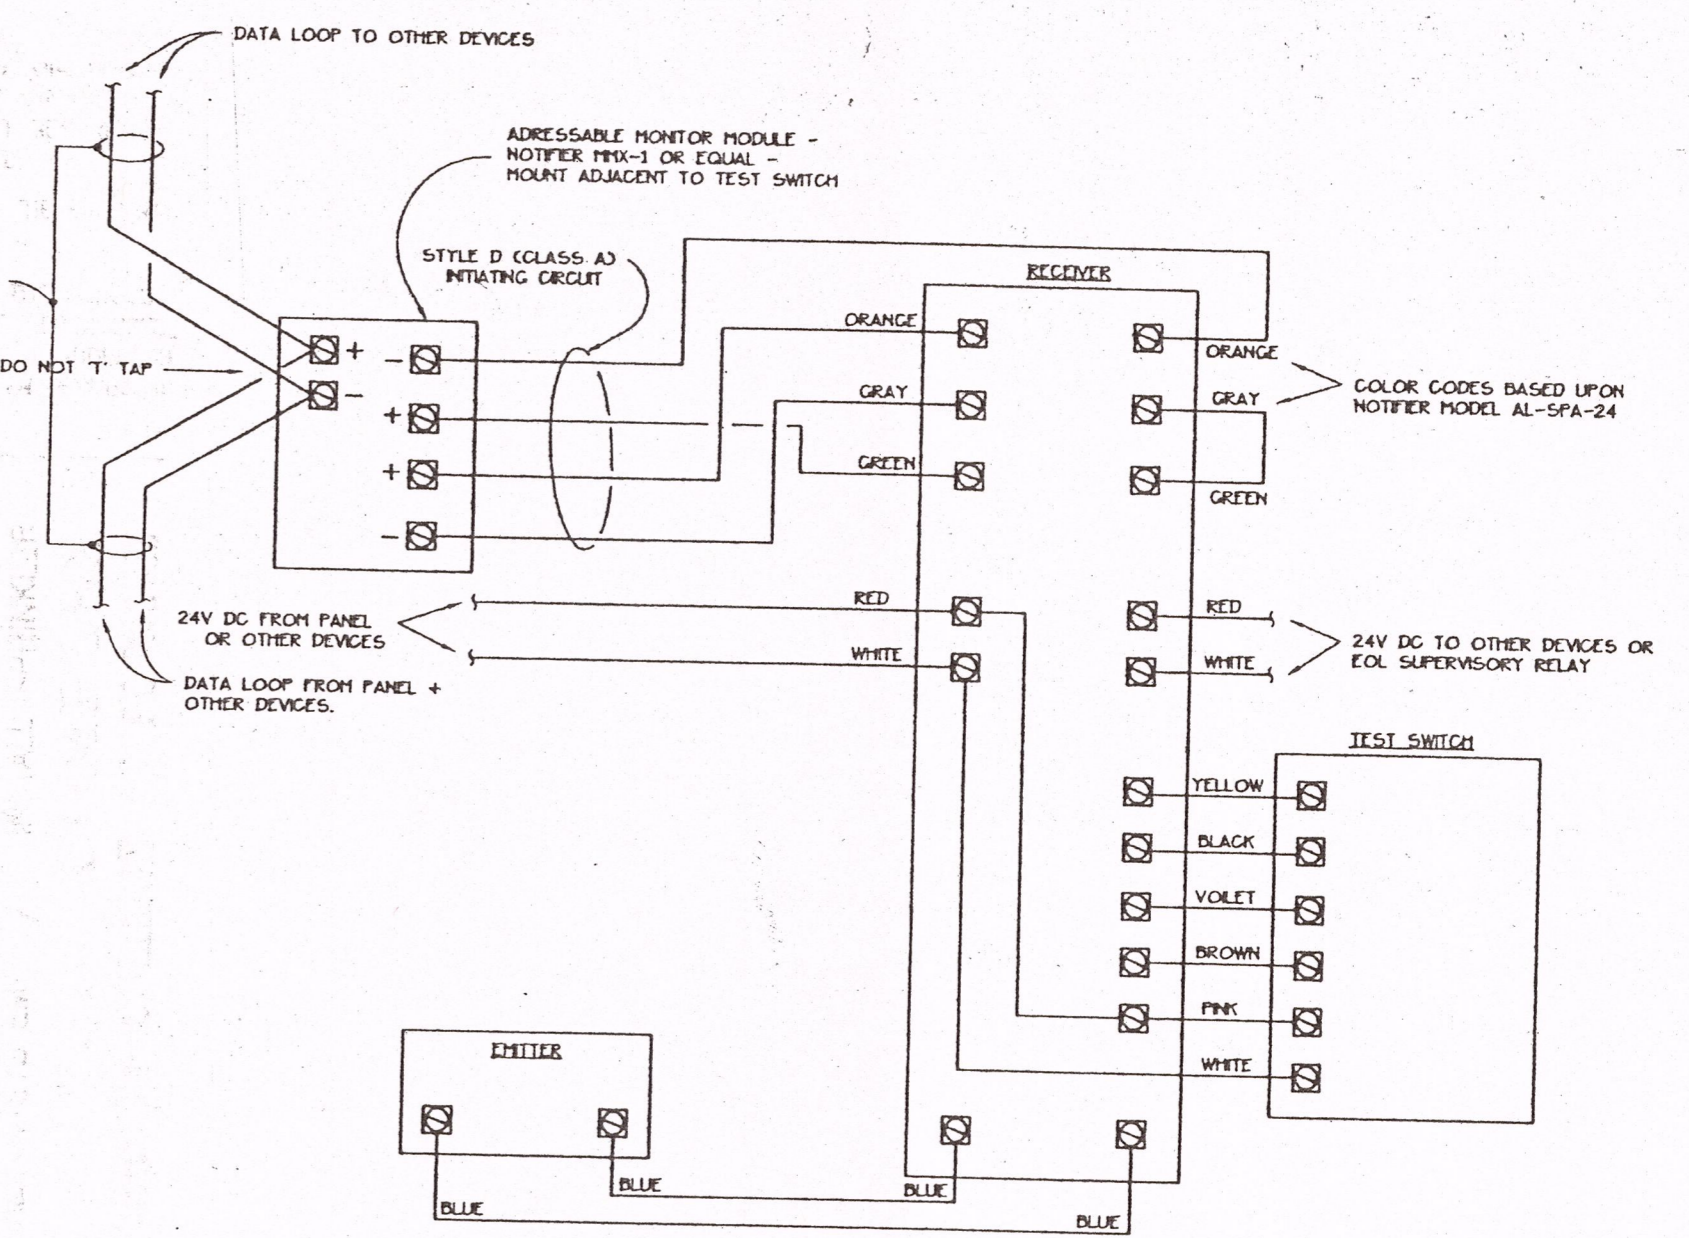


**DETAIL-WIRING OF BEAM TYPE SMOKE DETECTORS**

N.T.S.

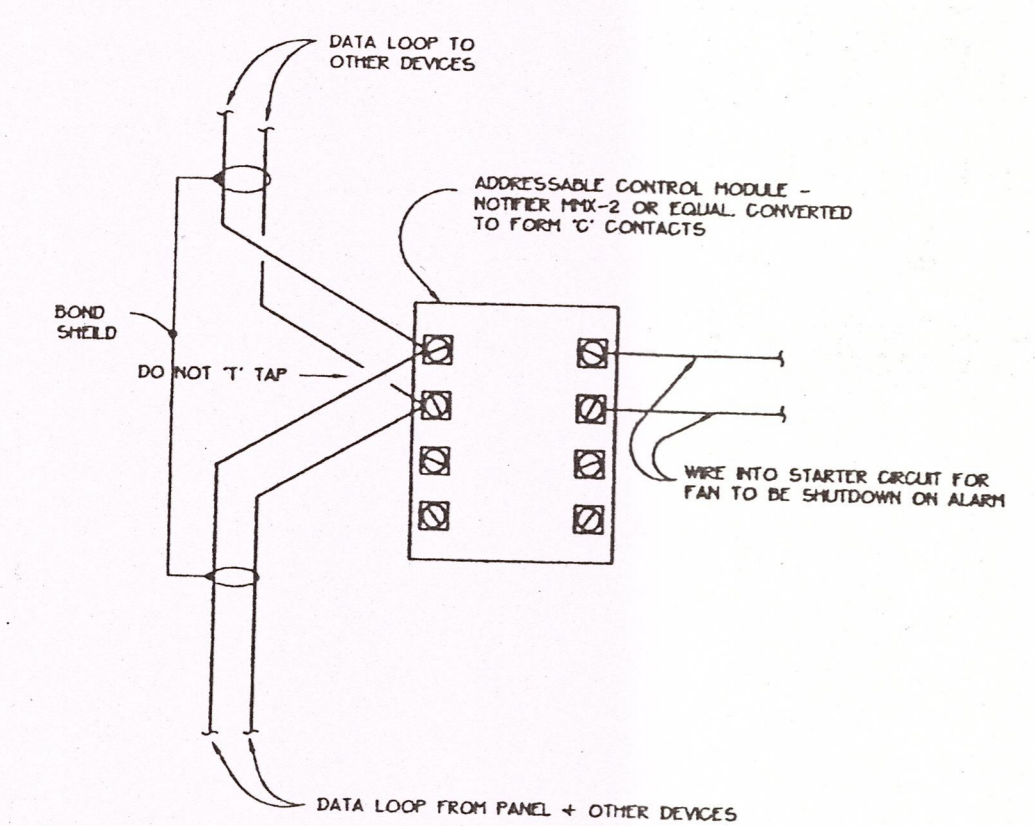


**DETAIL - FAN SHUTDOWN WIRING**

N.T.S.

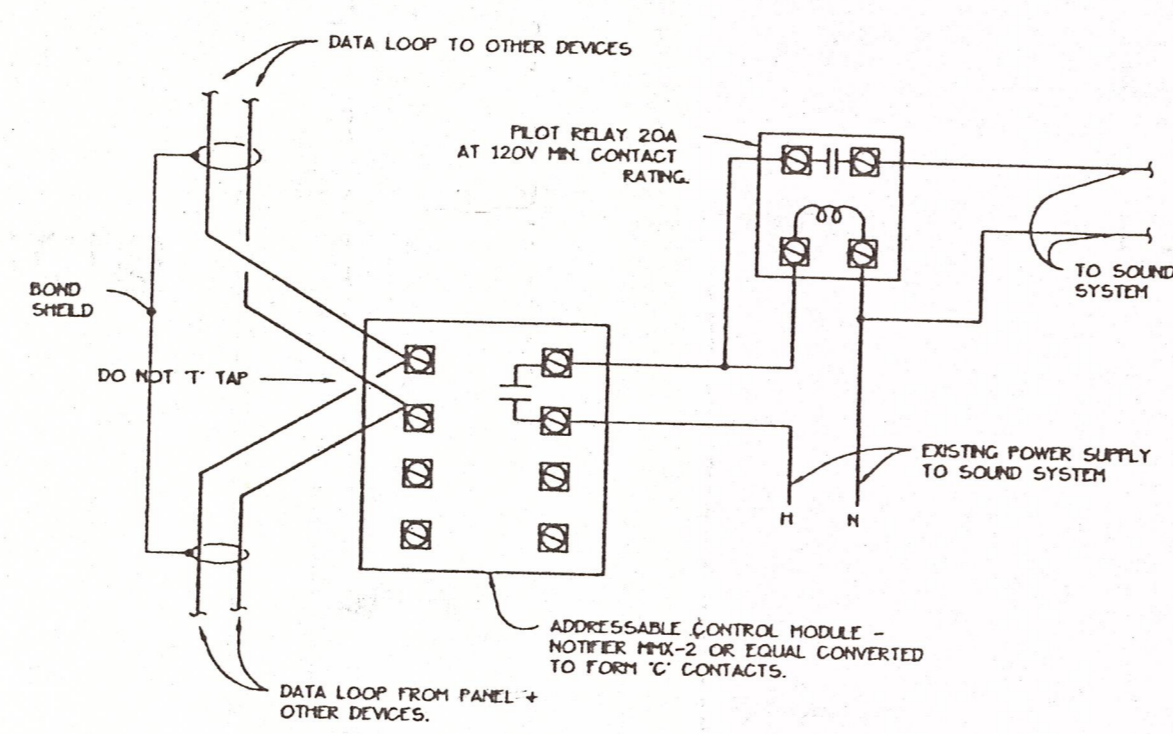


**DETAIL - SOUND SYSTEM DISABLE WIRING**

N.T.S.

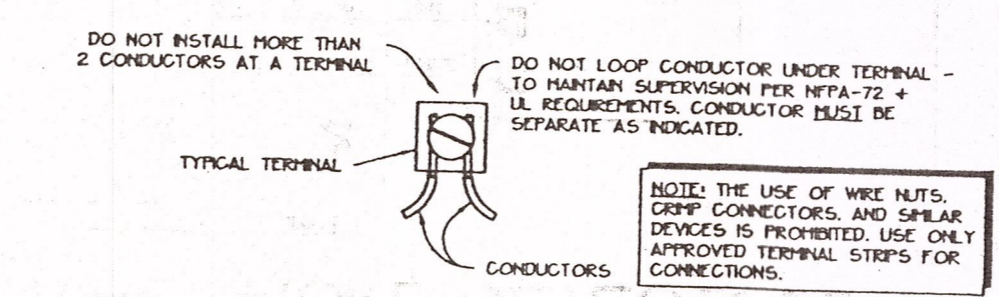


**DETAIL - TYPICAL TERMINAL**

N.T.S.

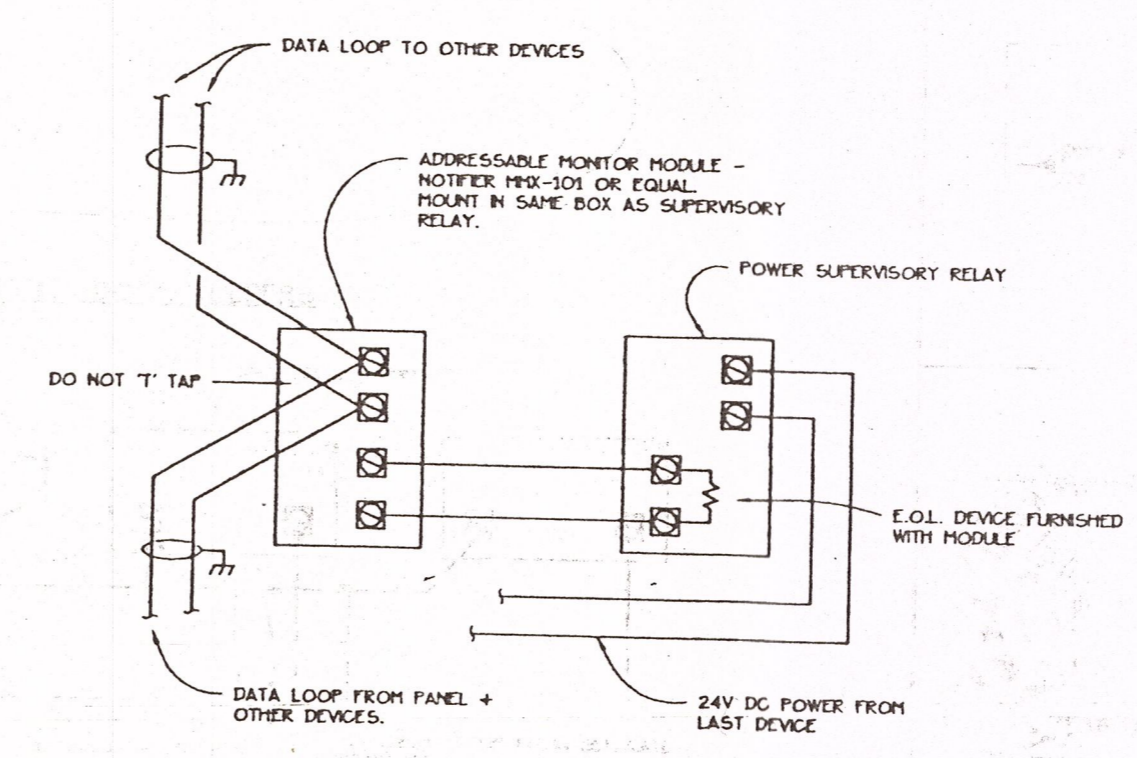


**DETAIL-WIRING OF POWER SUPERVISORY RELAY**

N.T.S.

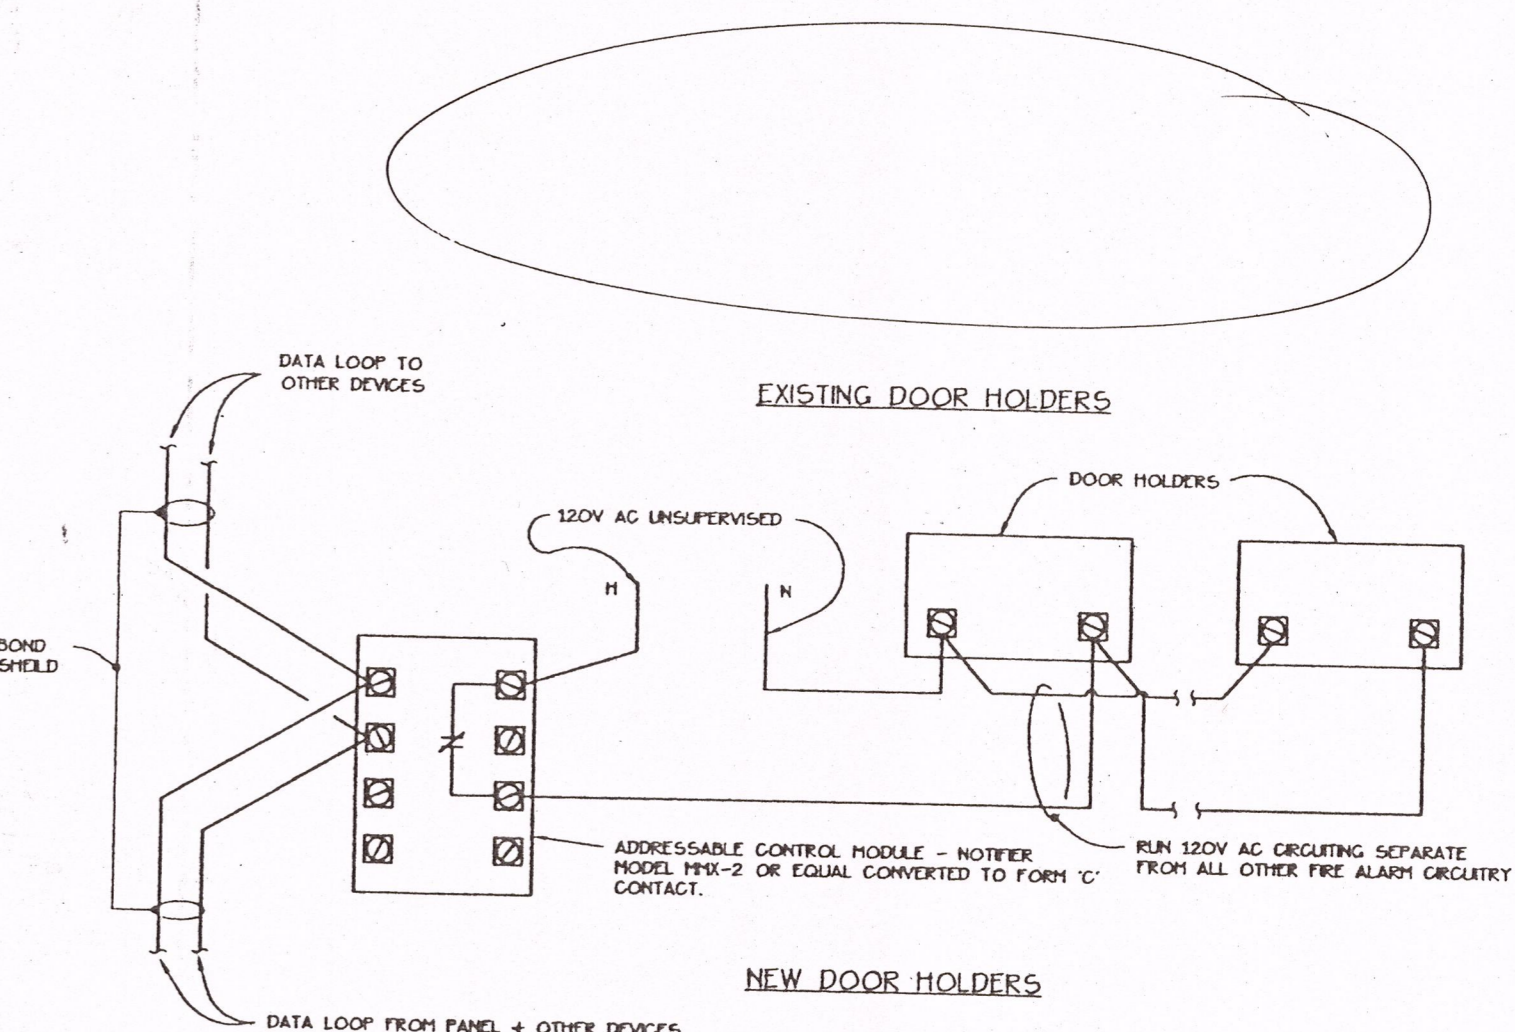


**DOOR HOLDER CONTROL**

N.T.S.

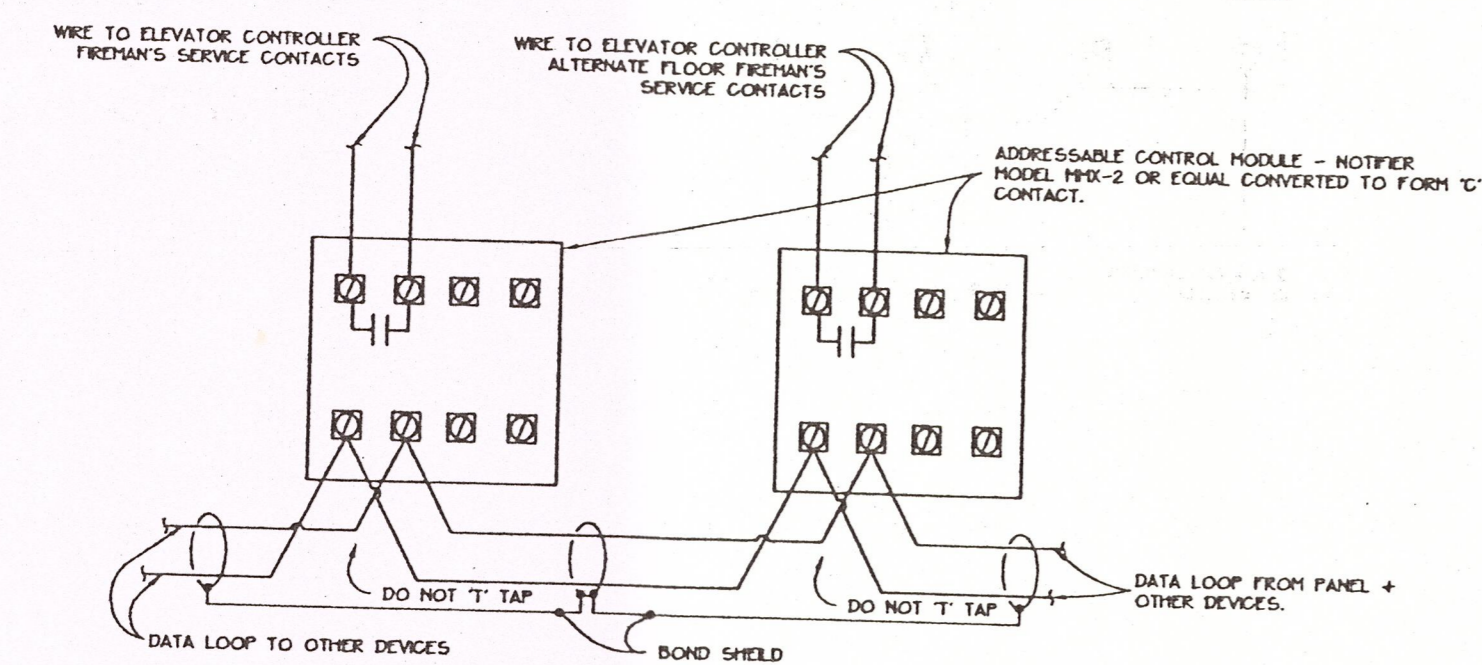

**WIRING OF ELEVATOR FIRE SERVICE**

N.T.S.

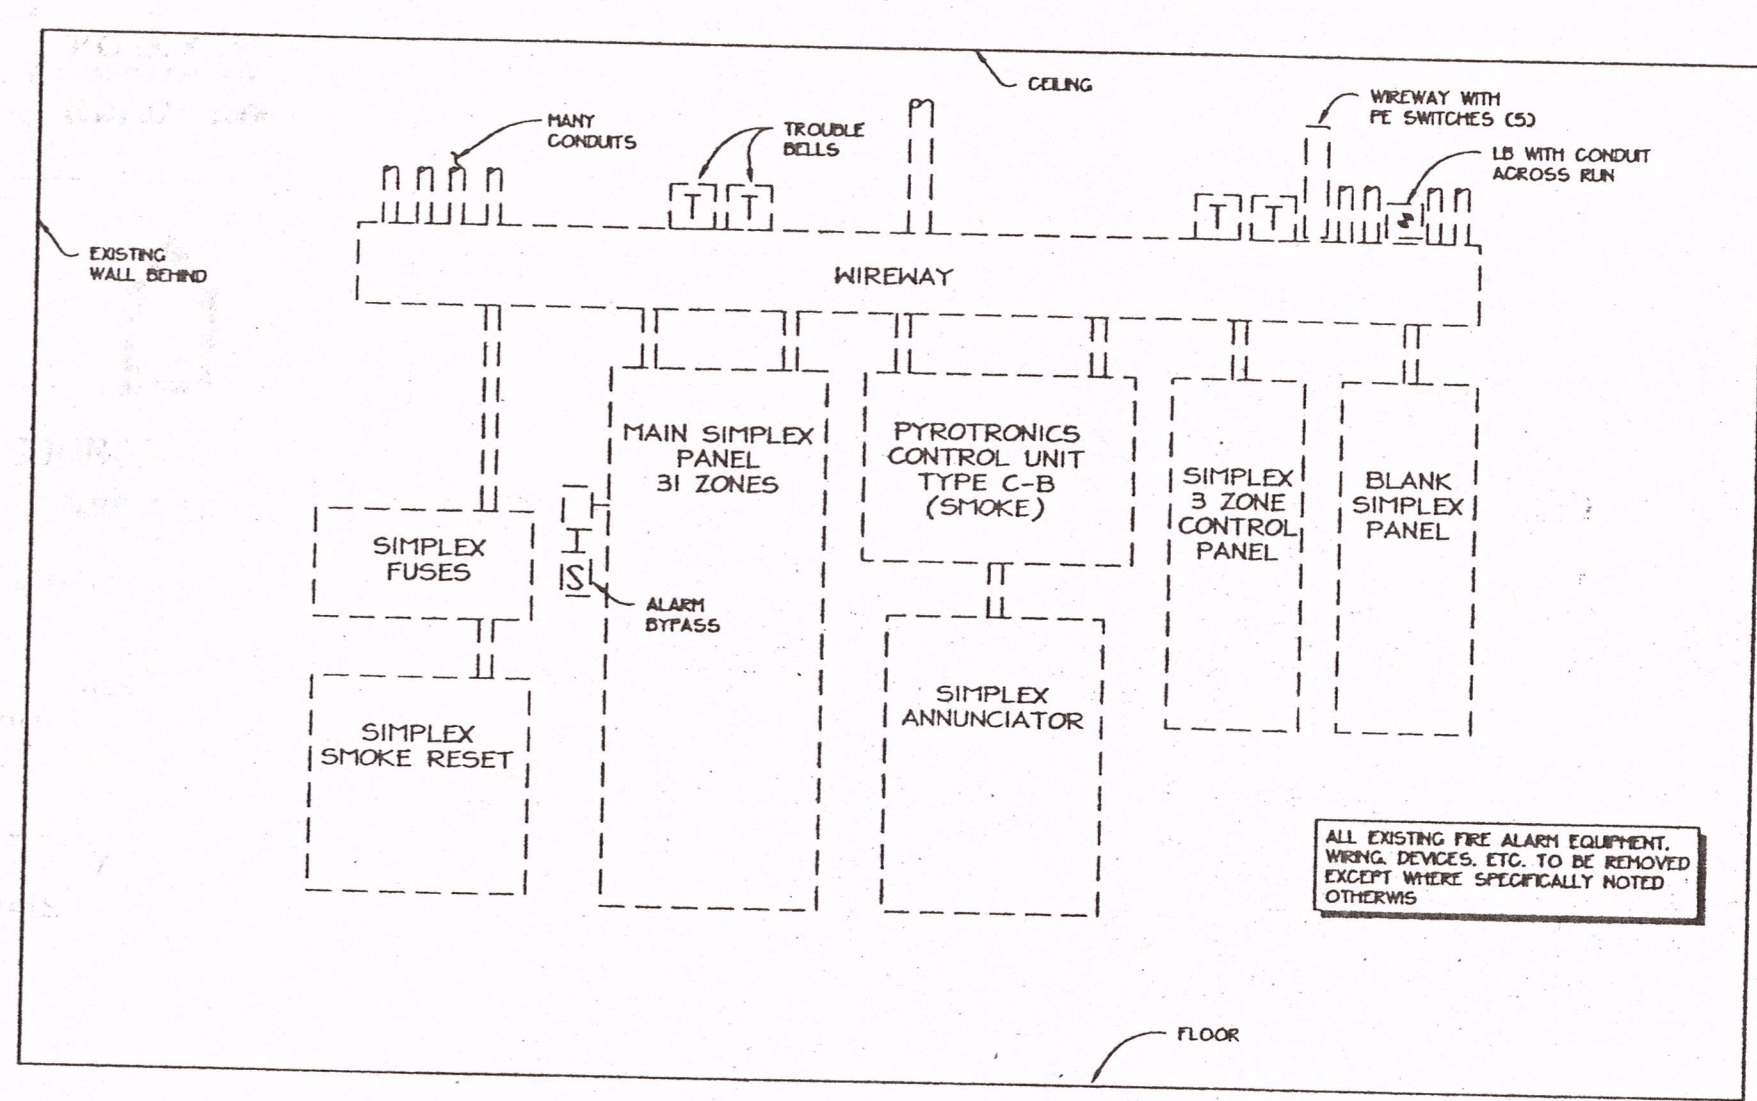

**ELEVATION OF EXISTING F.A. EQUIPMENT**

N.T.S.

DRAWING A-23  
 Adden #2  
 1/7/98

Detail: Wiring of Elevator Fire Service:  
 Omit wiring of monitor modules to elevator controllers. Provide end of line resistor in lieu thereof.  
 Provide wiring diagram in box to show how elevator recall is to be wired in the future.  
 Change title of detail to "Wiring of Future Elevator Fire Service".



Detail: Door Holder Control, Existing Door Holders:  
 This portion of detail not shown on drawings. Existing door holders are to be rewired to closest transponder using new wire/cable & conduit.  
 Provide appropriate power supply. Wire through dry contact in transponder to close doors on alarm.

D116

EA95073VA23 8-5-97 104719 pn EST

CONTRACTOR SHALL CHECK AND FIELD VERIFY ALL DIMENSIONS AND REPORT DISCREPANCIES TO THE ARCHITECT BEFORE ANY WORK IS COMMENCED.  
 ALL DRAWINGS ARE THE PROPERTY OF THE ARCHITECT.  
 THIS DESIGN AND THESE DOCUMENTS MAY NOT BE REPRODUCED, REUSED, ALTERED OR ADDED TO WITHOUT THE WRITTEN PERMISSION OF THE ARCHITECT.

STATE UNIVERSITY  
 CONSTRUCTION FUND  
 SUCF PROJECT NUMBER 12130  
 REPLACE FIRE ALARM SYSTEM / INSTALL SPRINKLER CRANE MUSIC COMPLEX  
 STATE UNIVERSITY COLLEGE AT POTSDAM

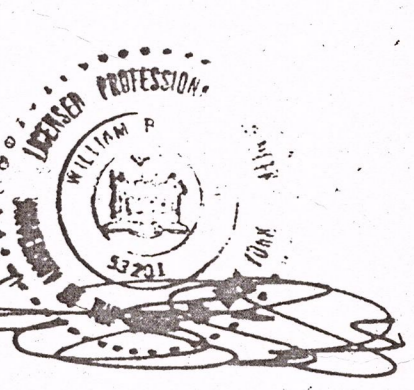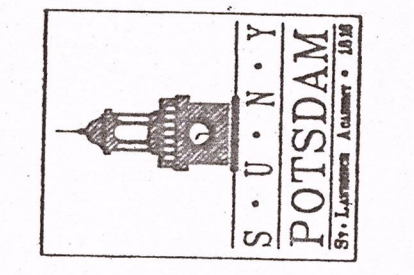

**HA2F**  
 CONSULTANTS  
 IN  
 ENGINEERING  
 P.O. BOX 226  
 CLIFTON PARK, NY 12085  
 (518) 877-8566

**O'CONNOR & MARSH**  
 ARCHITECTS  
 FACILITY DESIGN - PLANNING  
 517 OVER THE LIBRARY  
 WESTERN AVENUE  
 ALBANY, NEW YORK 12203  
 518 459 0611

DRAWING TITLE  
 DETAILS

DATE  
 12-9-97  
 DRAWING NO.  
 12130

**A23**