



D116

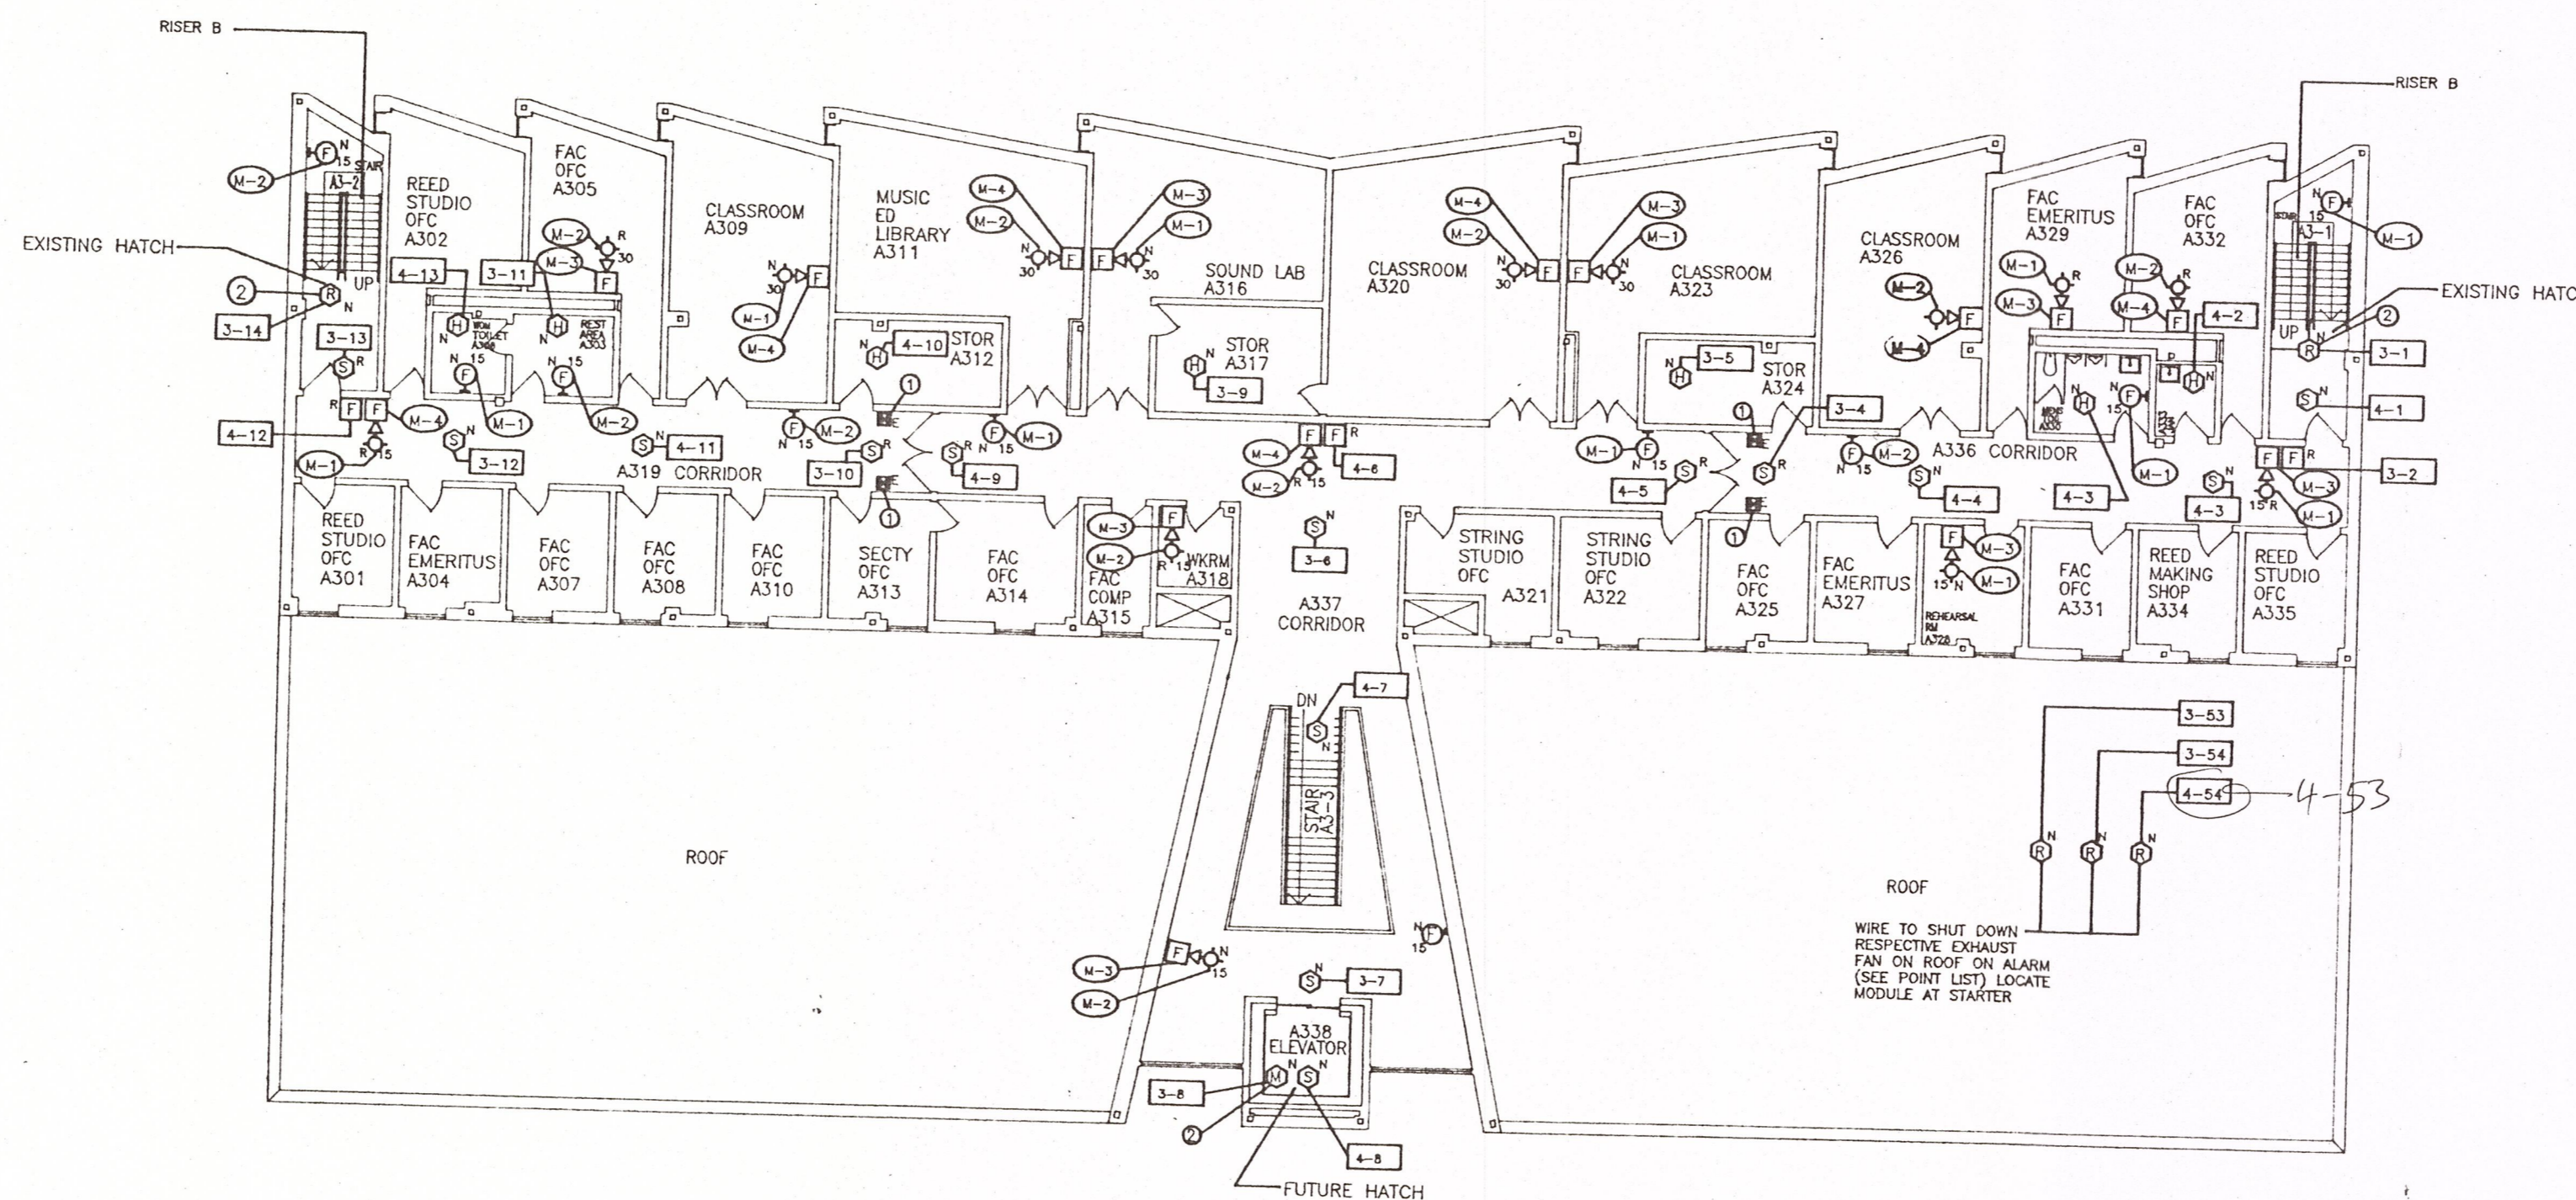

1
A4 UPPER PLAN - LEVEL 3
SCALE: 1/16" = 1'-0"

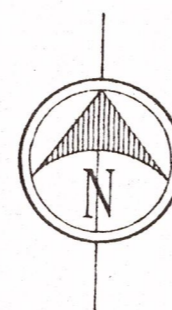


KEY NOTES:

- ① REWIRE EXISTING DOOR HOLDERS TO NEW FIRE ALARM PANEL. SEE DETAIL AND RISER DIAGRAM.
- ② WIRE TO (FUTURE) SMOKE HATCH AS NOTED. SEE DETAIL. FOR EXISTING HATCHES, REMOVE EXISTING CONTROL; MAINTAIN POWER SUPPLY.

CONTRACTOR SHALL CHECK AND FIELD VERIFY ALL DIMENSIONS AND REPORT DISCREPANCIES TO THE ARCHITECT BEFORE ANY WORK IS COMMENCED.
ALL DRAWINGS ARE THE PROPERTY OF THE ARCHITECT.
THIS DESIGN AND THESE DOCUMENTS MAY NOT BE REPRODUCED, REUSED, ALTERED OR ADDED TO WITHOUT THE WRITTEN PERMISSION OF THE ARCHITECT.

STATE UNIVERSITY
CONSTRUCTION FUND
SUCF PROJECT NUMBER 12130
REPLACE FIRE ALARM SYSTEM / INSTALL SPRINKLER
CRANE MUSIC COMPLEX
STATE UNIVERSITY COLLEGE AT POTSDAM

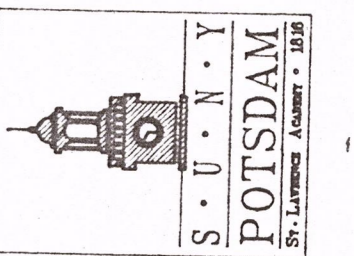

HAZF CONSULTANTS IN ENGINEERING
P.O. BOX 226
CLIFTON PARK, N.Y. 12065
TEL: (518) 877-8508
FAX: (518) 877-8509

OCM PROJECT NO. 10233



O'CONNOR & MARSH
ARCHITECTS

FACILITY DESIGN - PLANNING

517 OVER THE LIBRARY
WESTERN AVENUE
ALBANY, NEW YORK 12203
518 459 0811

DRAWING TITLE
SCHUTTE HALL -
LEVEL 3

DATE
12-9-97

DRAWING NO.

SUCF PROJECT NO.
12130

A4

SCHUTTE HALL (BLDG. NO. 9A)