

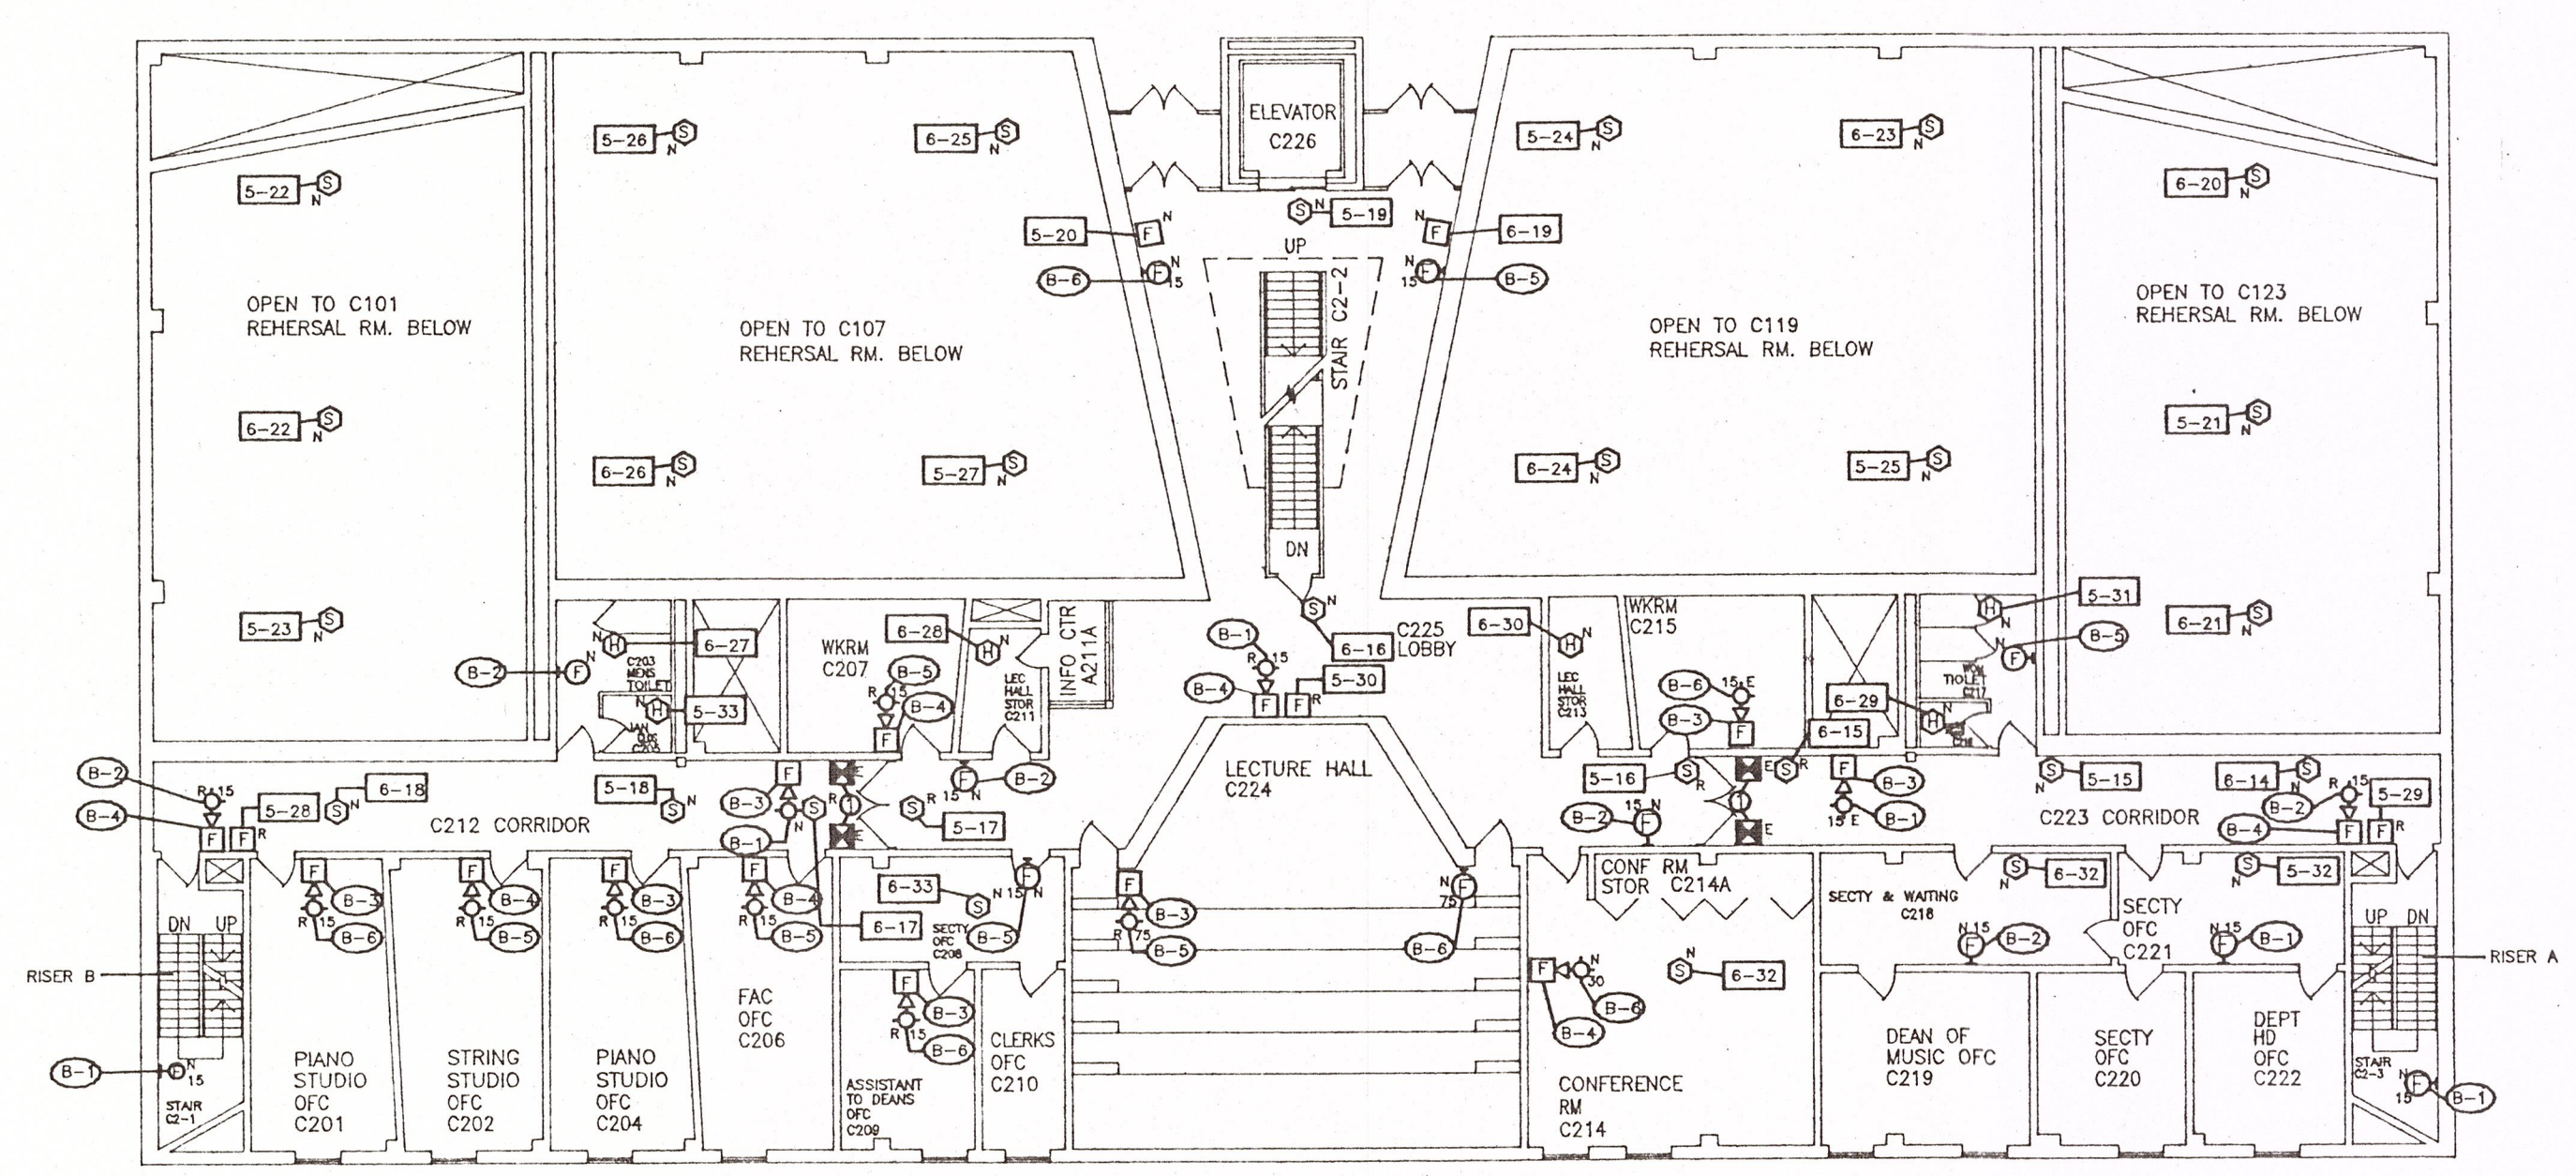


1 LOWER PLAN - LEVEL 1
A5 SCALE: 1/16" = 1'-0"

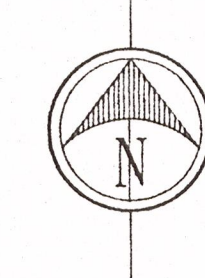


2 PLAZA PLAN - LEVEL 2
A5 SCALE: 1/16" = 1'-0"

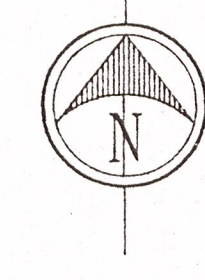

KEY NOTES:


- 1 REWIRE TO EXISTING DOOR HOLDERS TO NEW FIRE ALARM PANEL. SEE DETAIL AND RISER DIAGRAMS.

KEY PLAN: CRANE MUSIC COMPLEX

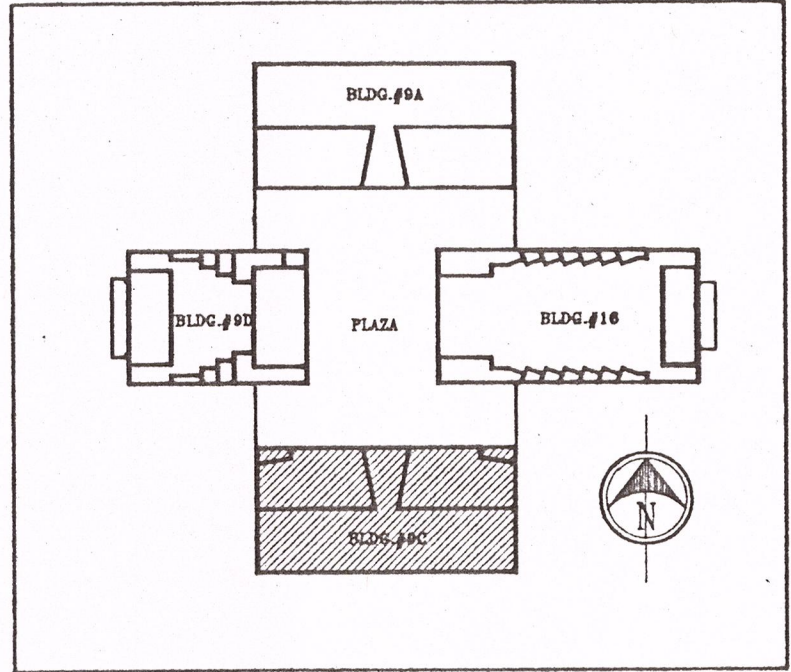

CONTRACTOR SHALL CHECK AND FIELD VERIFY ALL DIMENSIONS AND REPORT DISCREPANCIES TO THE ARCHITECT BEFORE ANY WORK IS COMMENCED.
ALL DRAWINGS ARE THE PROPERTY OF THE ARCHITECT.
THIS DESIGN AND THESE DOCUMENTS MAY NOT BE REPRODUCED, REUSED, ALTERED OR ADDED TO WITHOUT THE WRITTEN PERMISSION OF THE ARCHITECT.

STATE UNIVERSITY
CONSTRUCTION FUND
SUCF PROJECT NUMBER 12130
REPLACE FIRE ALARM SYSTEM / INSTALL SPRINKLER
CRANE MUSIC COMPLEX
STATE UNIVERSITY COLLEGE AT POTSDAM

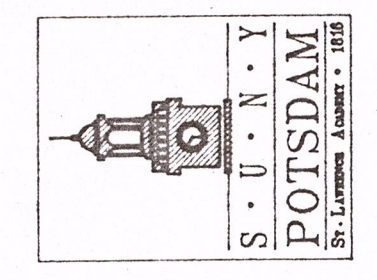

HAZF, CONSULTANTS IN ENGINEERING
P.O. BOX 228
CLIFTON PARK, N.Y. 12065
TEL: (518) 877-8566
FAX: (518) 877-8569

OCM PROJECT NO. 10233

O'CONNOR & MARSH
ARCHITECTS

FACILITY DESIGN - PLANNING

517 OVER THE LIBRARY
WESTERN AVENUE
ALBANY, NEW YORK 12203
518 458 0611

DRAWING TITLE
BISHOP HALL -
LEVEL 1, & LEVEL 2

DATE
12-9-97
SUCF PROJECT NO.
12130

DRAWING NO.
A5

BISHOP HALL (BLDG. NO. 9C)

D116