



D116

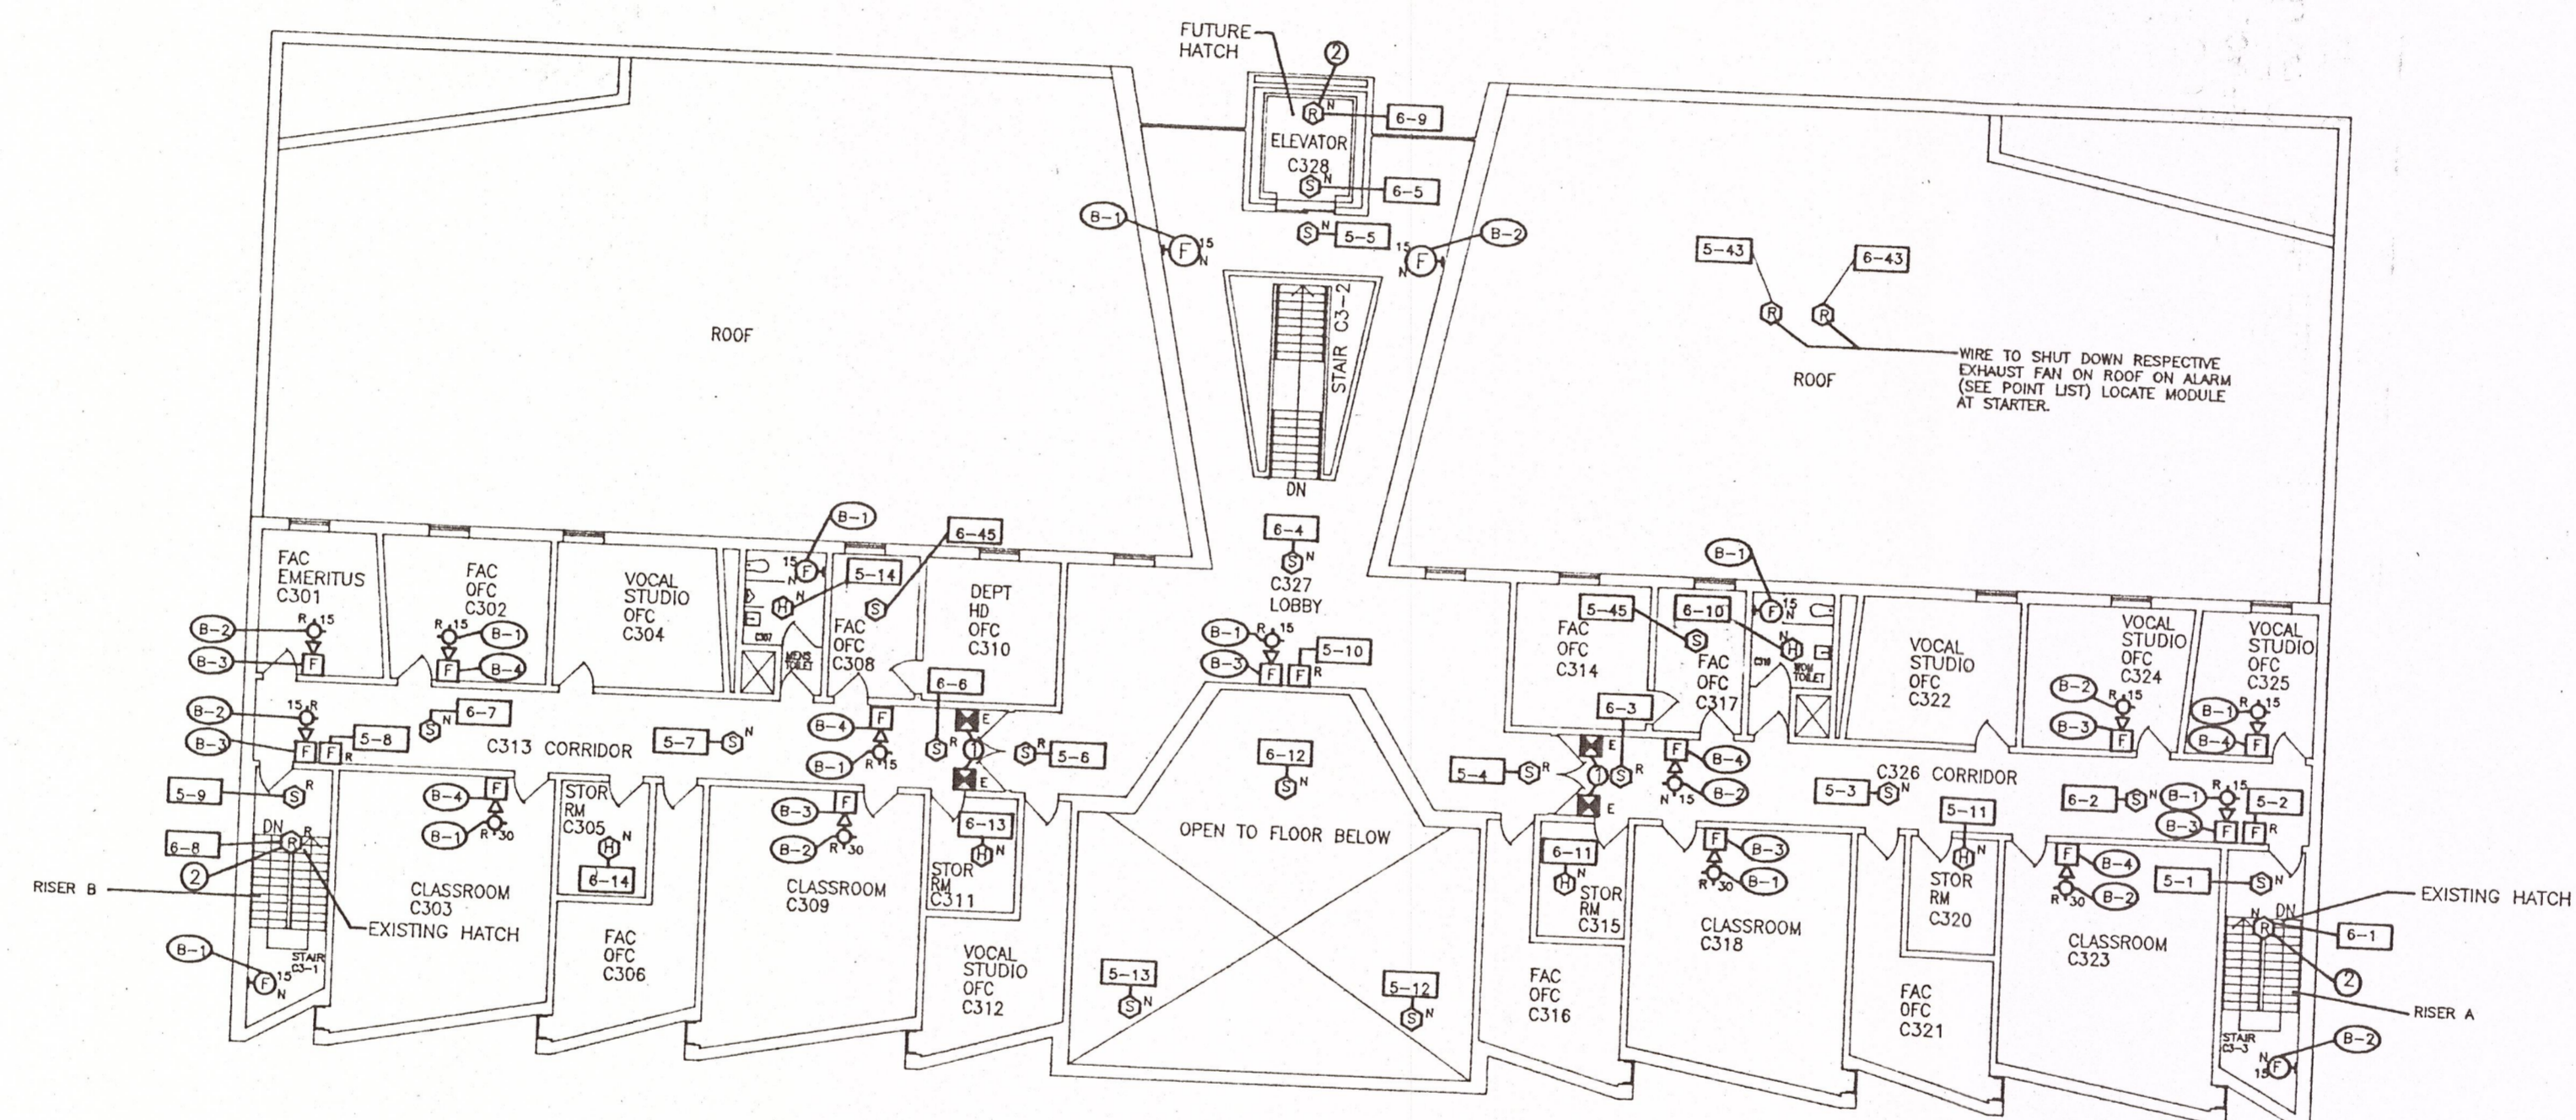

1 UPPER PLAN - LEVEL 3
 A6 SCALE: 1/16" = 1'-0"


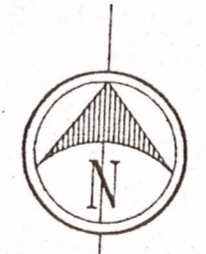


KEY NOTES:

- ① REWIRE EXISTING DOOR HOLDERS TO NEW FIRE ALARM PANEL. SEE DETAIL AND RISER DIAGRAM.
- ② WIRE TO (FUTURE) LINE SMOKE HATCH AS NOTED. SEE DETAIL FOR EXISTING HATCHES, REMOVE EXISTING CONTROL; MAINTAIN POWER SUPPLY.


CONTRACTOR SHALL CHECK AND FIELD VERIFY ALL DIMENSIONS AND REPORT DISCREPANCIES TO THE ARCHITECT BEFORE ANY WORK IS COMMENCED.
 ALL DRAWINGS ARE THE PROPERTY OF THE ARCHITECT.
 THIS DESIGN AND THESE DOCUMENTS MAY NOT BE REPRODUCED, REUSED, ALTERED OR ADDED TO WITHOUT THE WRITTEN PERMISSION OF THE ARCHITECT.

STATE UNIVERSITY
 CONSTRUCTION FUND
 SUCF PROJECT NUMBER 12130
 REPLACE FIRE ALARM SYSTEM / INSTALL SPRINKLER CRANE MUSIC COMPLEX
 STATE UNIVERSITY COLLEGE AT POTSDAM

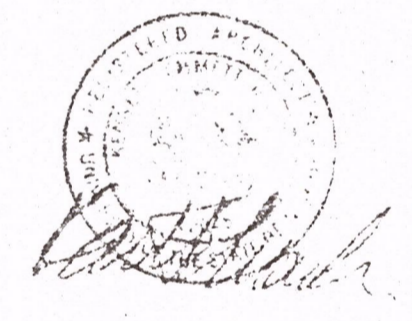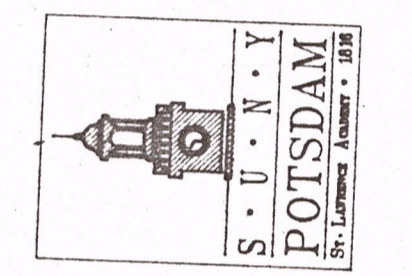

HAZF CONSULTANTS IN ENGINEERING
 P.O. BOX 226
 CLIFTON PARK, N.Y. 12065
 TEL: (518) 877-8586
 FAX: (518) 877-8588

OCM PROJECT NO. 10233

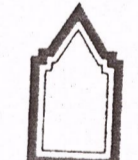

O'CONNOR & MARSH
 ARCHITECTS


FACILITY DESIGN - PLANNING

517 OVER THE LIBRARY
 WESTERN AVENUE
 ALBANY, NEW YORK 12203
 518 458 0811

DRAWING TITLE
 BISHOP HALL -
 LEVEL 3

DATE
 12-9-97

DRAWING NO.
A6

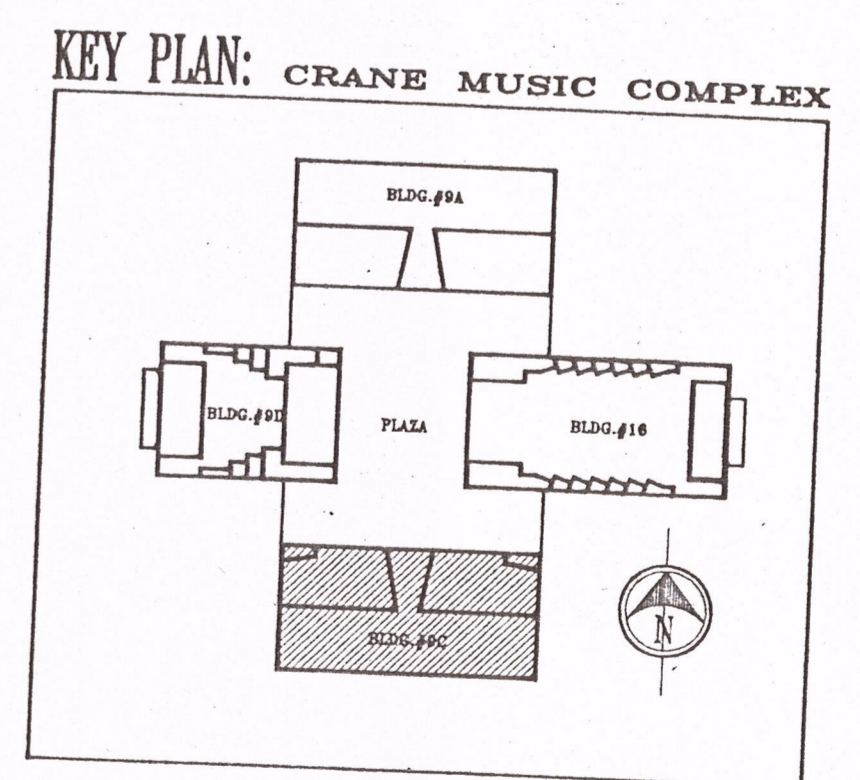

BISHOP HALL (BLDG. NO. 9C)

SUCF PROJECT NO.
 12130