



1 BASEMENT PLAN - LEVEL 0  
SCALE: 1/16" = 1'-0"

SEE DWG 1/A10 FOR MATCHLINE AT THIS AREA

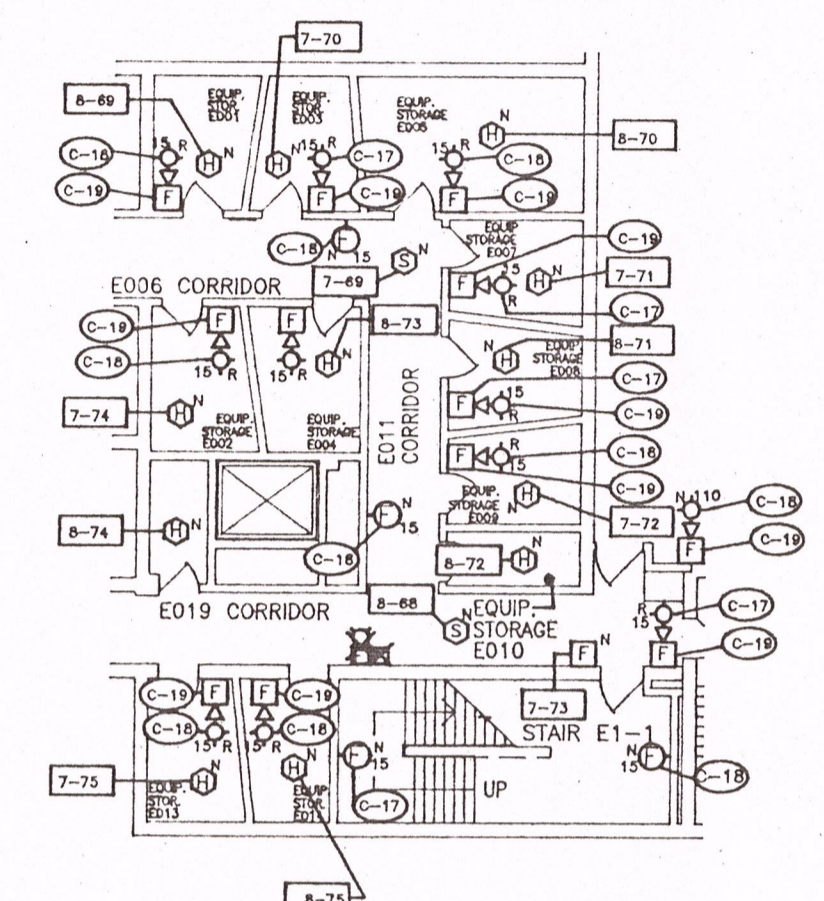


3 PARTIAL BASEMENT PLAN - LEVEL 0  
SCALE: 1/16" = 1'-0"

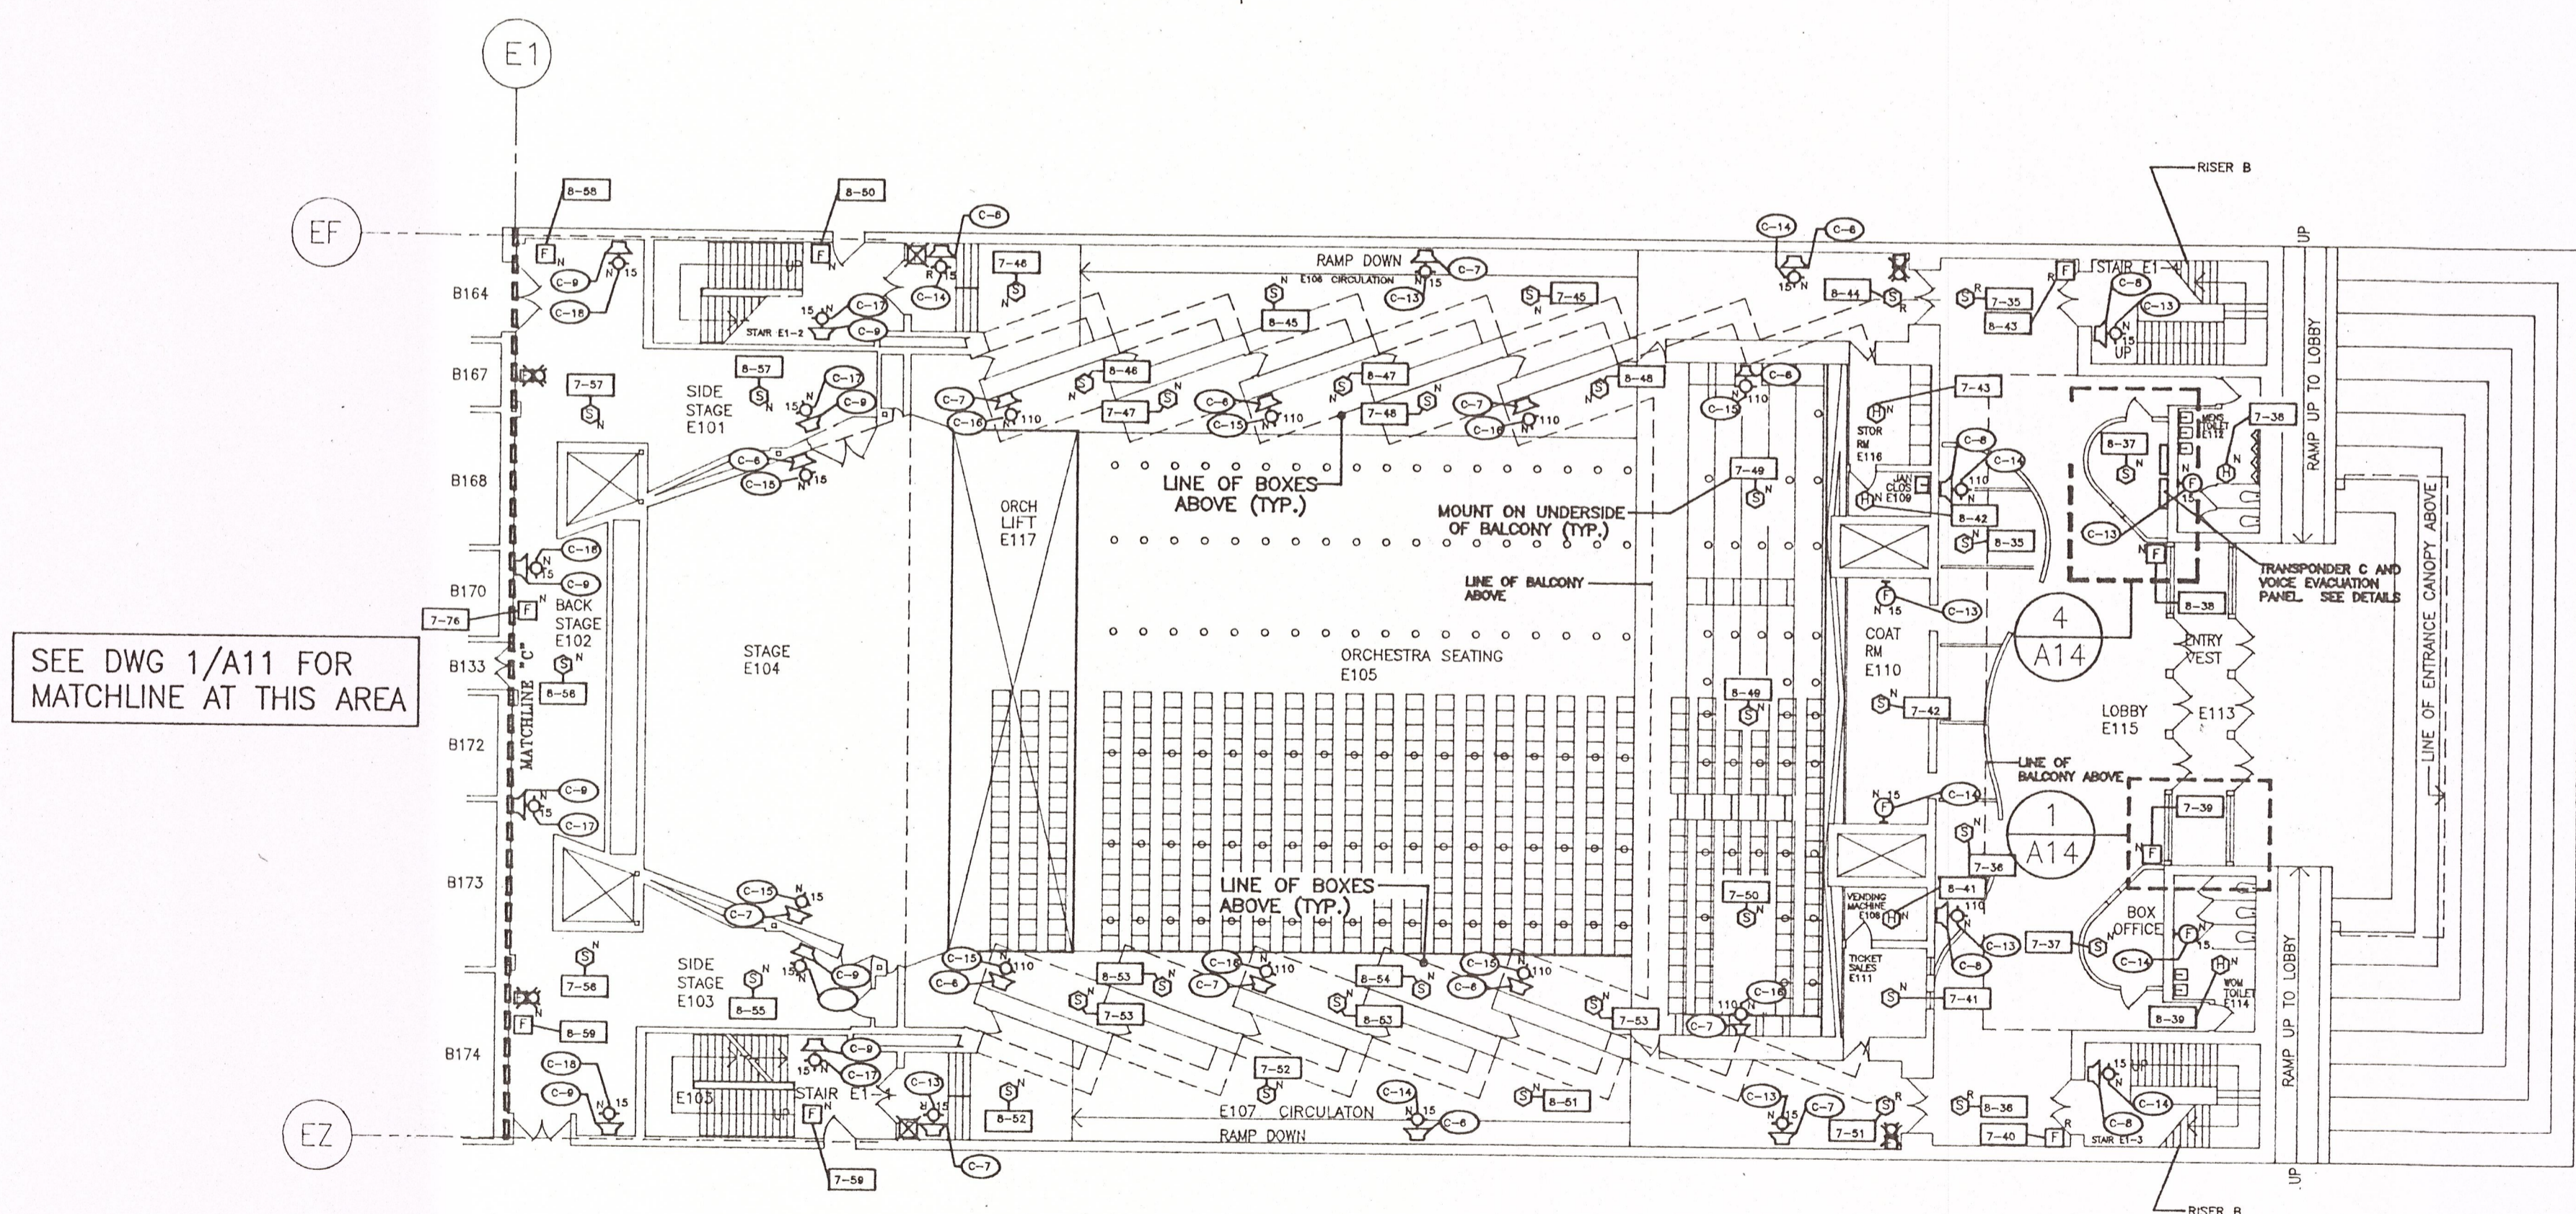

2 ORCHESTRA PLAN - LEVELS 1 & 1.1  
SCALE: 1/16" = 1'-0"



SEE DWG 1/A11 FOR MATCHLINE AT THIS AREA

KEY PLAN: CRANE MUSIC COMPLEX

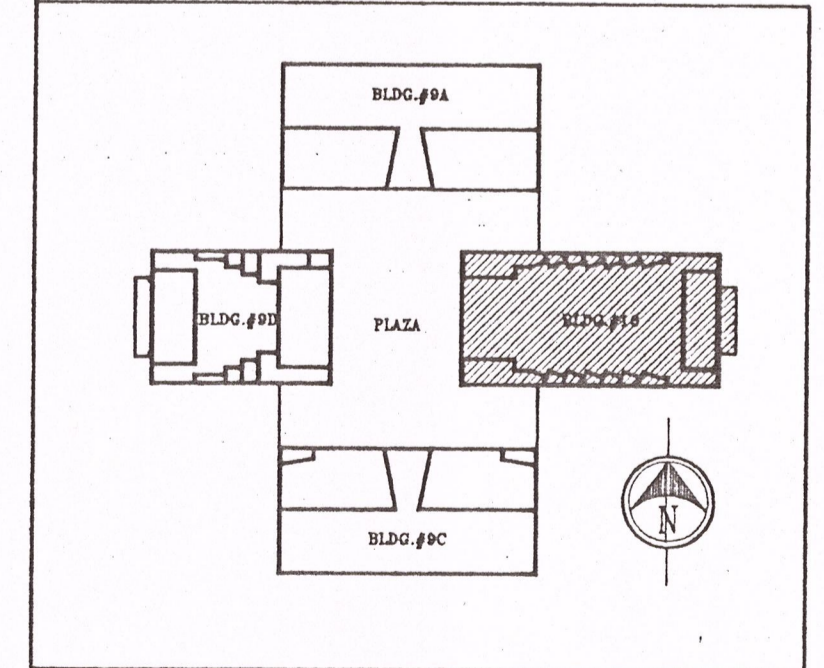

CONTRACTOR SHALL CHECK AND FIELD VERIFY ALL DIMENSIONS AND REPORT DISCREPANCIES TO THE ARCHITECT BEFORE ANY WORK IS COMMENCED.  
ALL DRAWINGS ARE THE PROPERTY OF THE ARCHITECT.  
THIS DESIGN AND THESE DOCUMENTS MAY NOT BE REPRODUCED, REUSED, ALTERED OR ADDED TO WITHOUT THE WRITTEN PERMISSION OF THE ARCHITECT.

STATE UNIVERSITY  
CONSTRUCTION FUND  
SUCF PROJECT NUMBER 12130  
REPLACE FIRE ALARM SYSTEM / INSTALL SPRINKLER  
CRANE MUSIC COMPLEX  
STATE UNIVERSITY COLLEGE AT POTSDAM

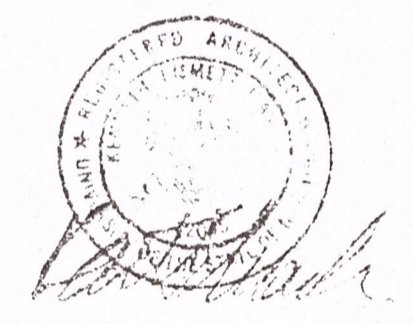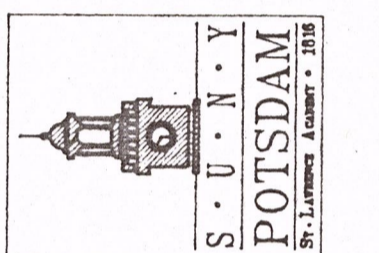

HAZF, CONSULTANTS IN ENGINEERING  
P.O. BOX 226  
CLIFTON PARK, NY 12065  
TEL: (518) 877-8506  
FAX: (518) 877-8500

OCM PROJECT NO. 10233

O'CONNOR & MARSH  
ARCHITECTS

FACILITY DESIGN - PLANNING

517 OVER THE LIBRARY  
WESTERN AVENUE  
ALBANY, NEW YORK 12203  
518 459 0611

DRAWING TITLE  
HOSMER CONCERT HALL -  
LEVEL 0,  
LEVELS 1, & 1.1

DATE  
12-9-97

DRAWING NO.  
A7

SUCF PROJECT NO.  
12130

HOSMER CONCERT HALL (BLDG. NO. 16)

D116