




LEGEND

1. RAYMOND HALL
3. FLAGG HALL
4. CRUMB MEMORIAL LIBRARY
5. MAXCY HALL
6. BOWMAN HALL
7. BOWMAN DINING HALL
- 9A. SCHUETTE HALL
- 9B. CRANE MUSIC CENTER
- 9C. BISHOP HALL
- 9D. SNELL MUSIC THEATER
10. SATTERLEE HALL
11. DUNN HALL
12. MERRITT HALL
13. HEATING PLANT
- 15A. MOREY HALL
- 15B. CARSON HALL
- 15C. MACVICAR HALL
- 15D. COMPUTER CENTER
16. HOSMER CONCERT HALL
17. SISSON HALL
18. VAN HOUSEN HALL
19. THATCHER HALL
20. DRAIME HALL
21. STOWELL HALL
22. KNOWLES DINING HALL
23. KNOWLES HALL
24. MAINTENANCE BLDG.
- 24A. FOOD SERVICE BLDG.
- 24B. GARAGE
25. KELLAS HALL
26. BRAINERD HALL
27. TIMERMAN HALL
28. LEHMAN HALL
29. COLLEGE UNION
30. LEHMAN DINING HALL

NOTE: THIS CONTRACT, SUCF PROJECT NO. 12130 INCLUDES ONLY THOSE BUILDINGS WHICH ARE SHADED


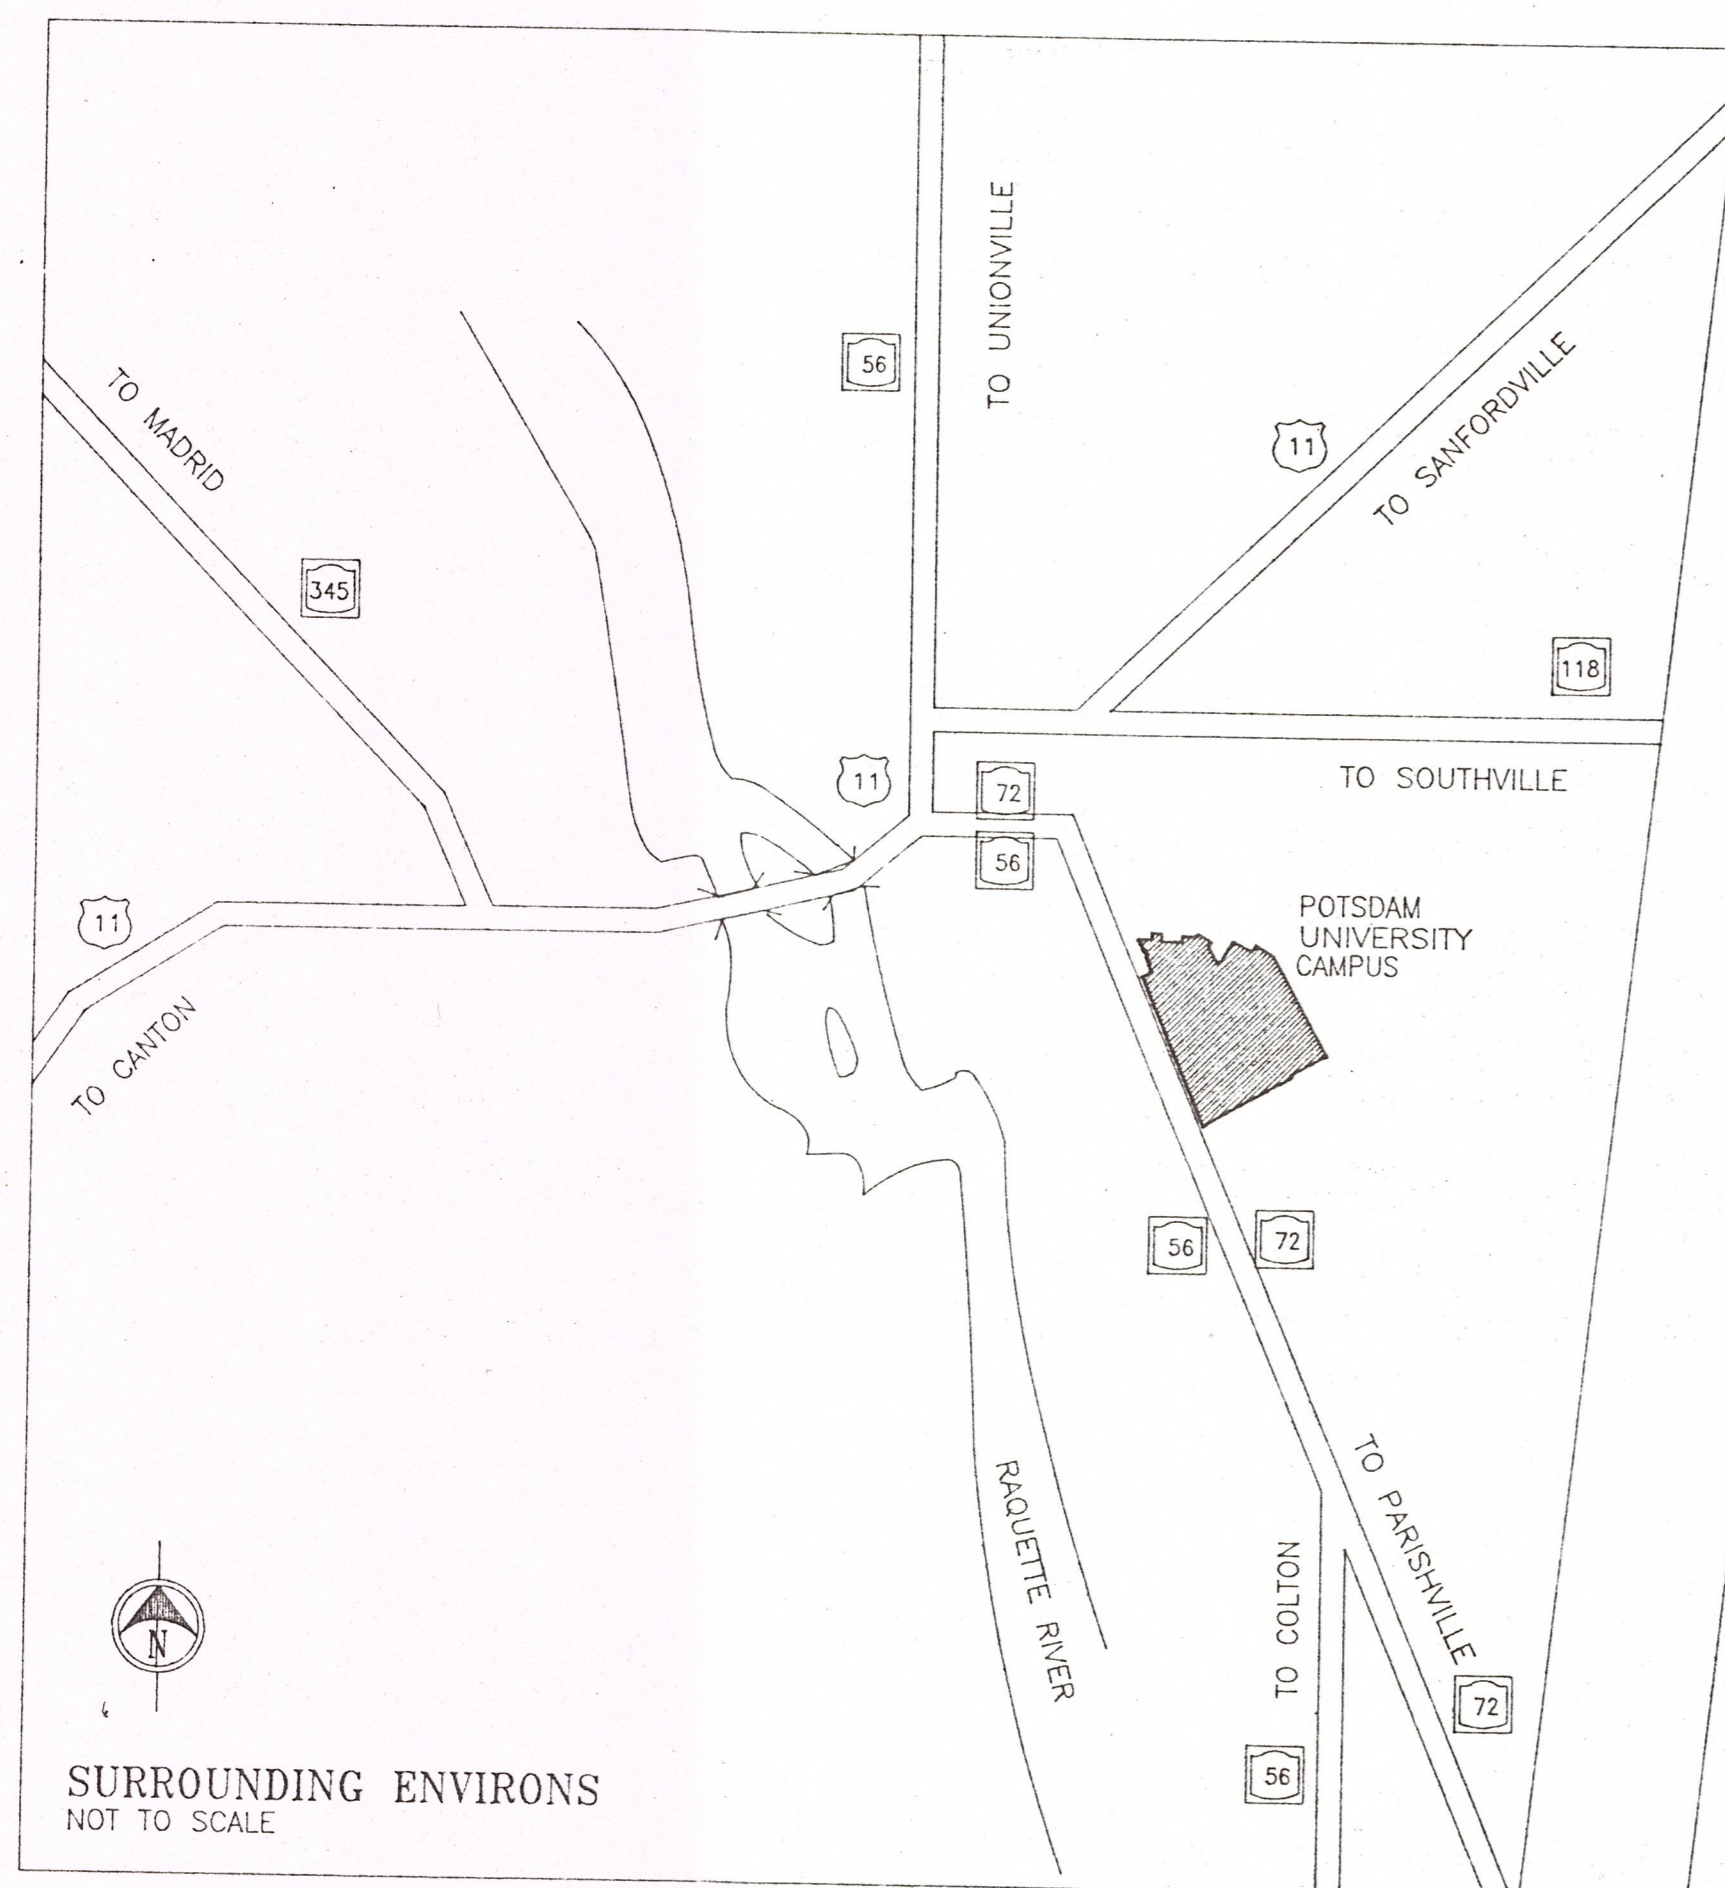


 PUBLIC SAFETY OFFICE
IN DUNN HALL—SEE
SHEET A-16

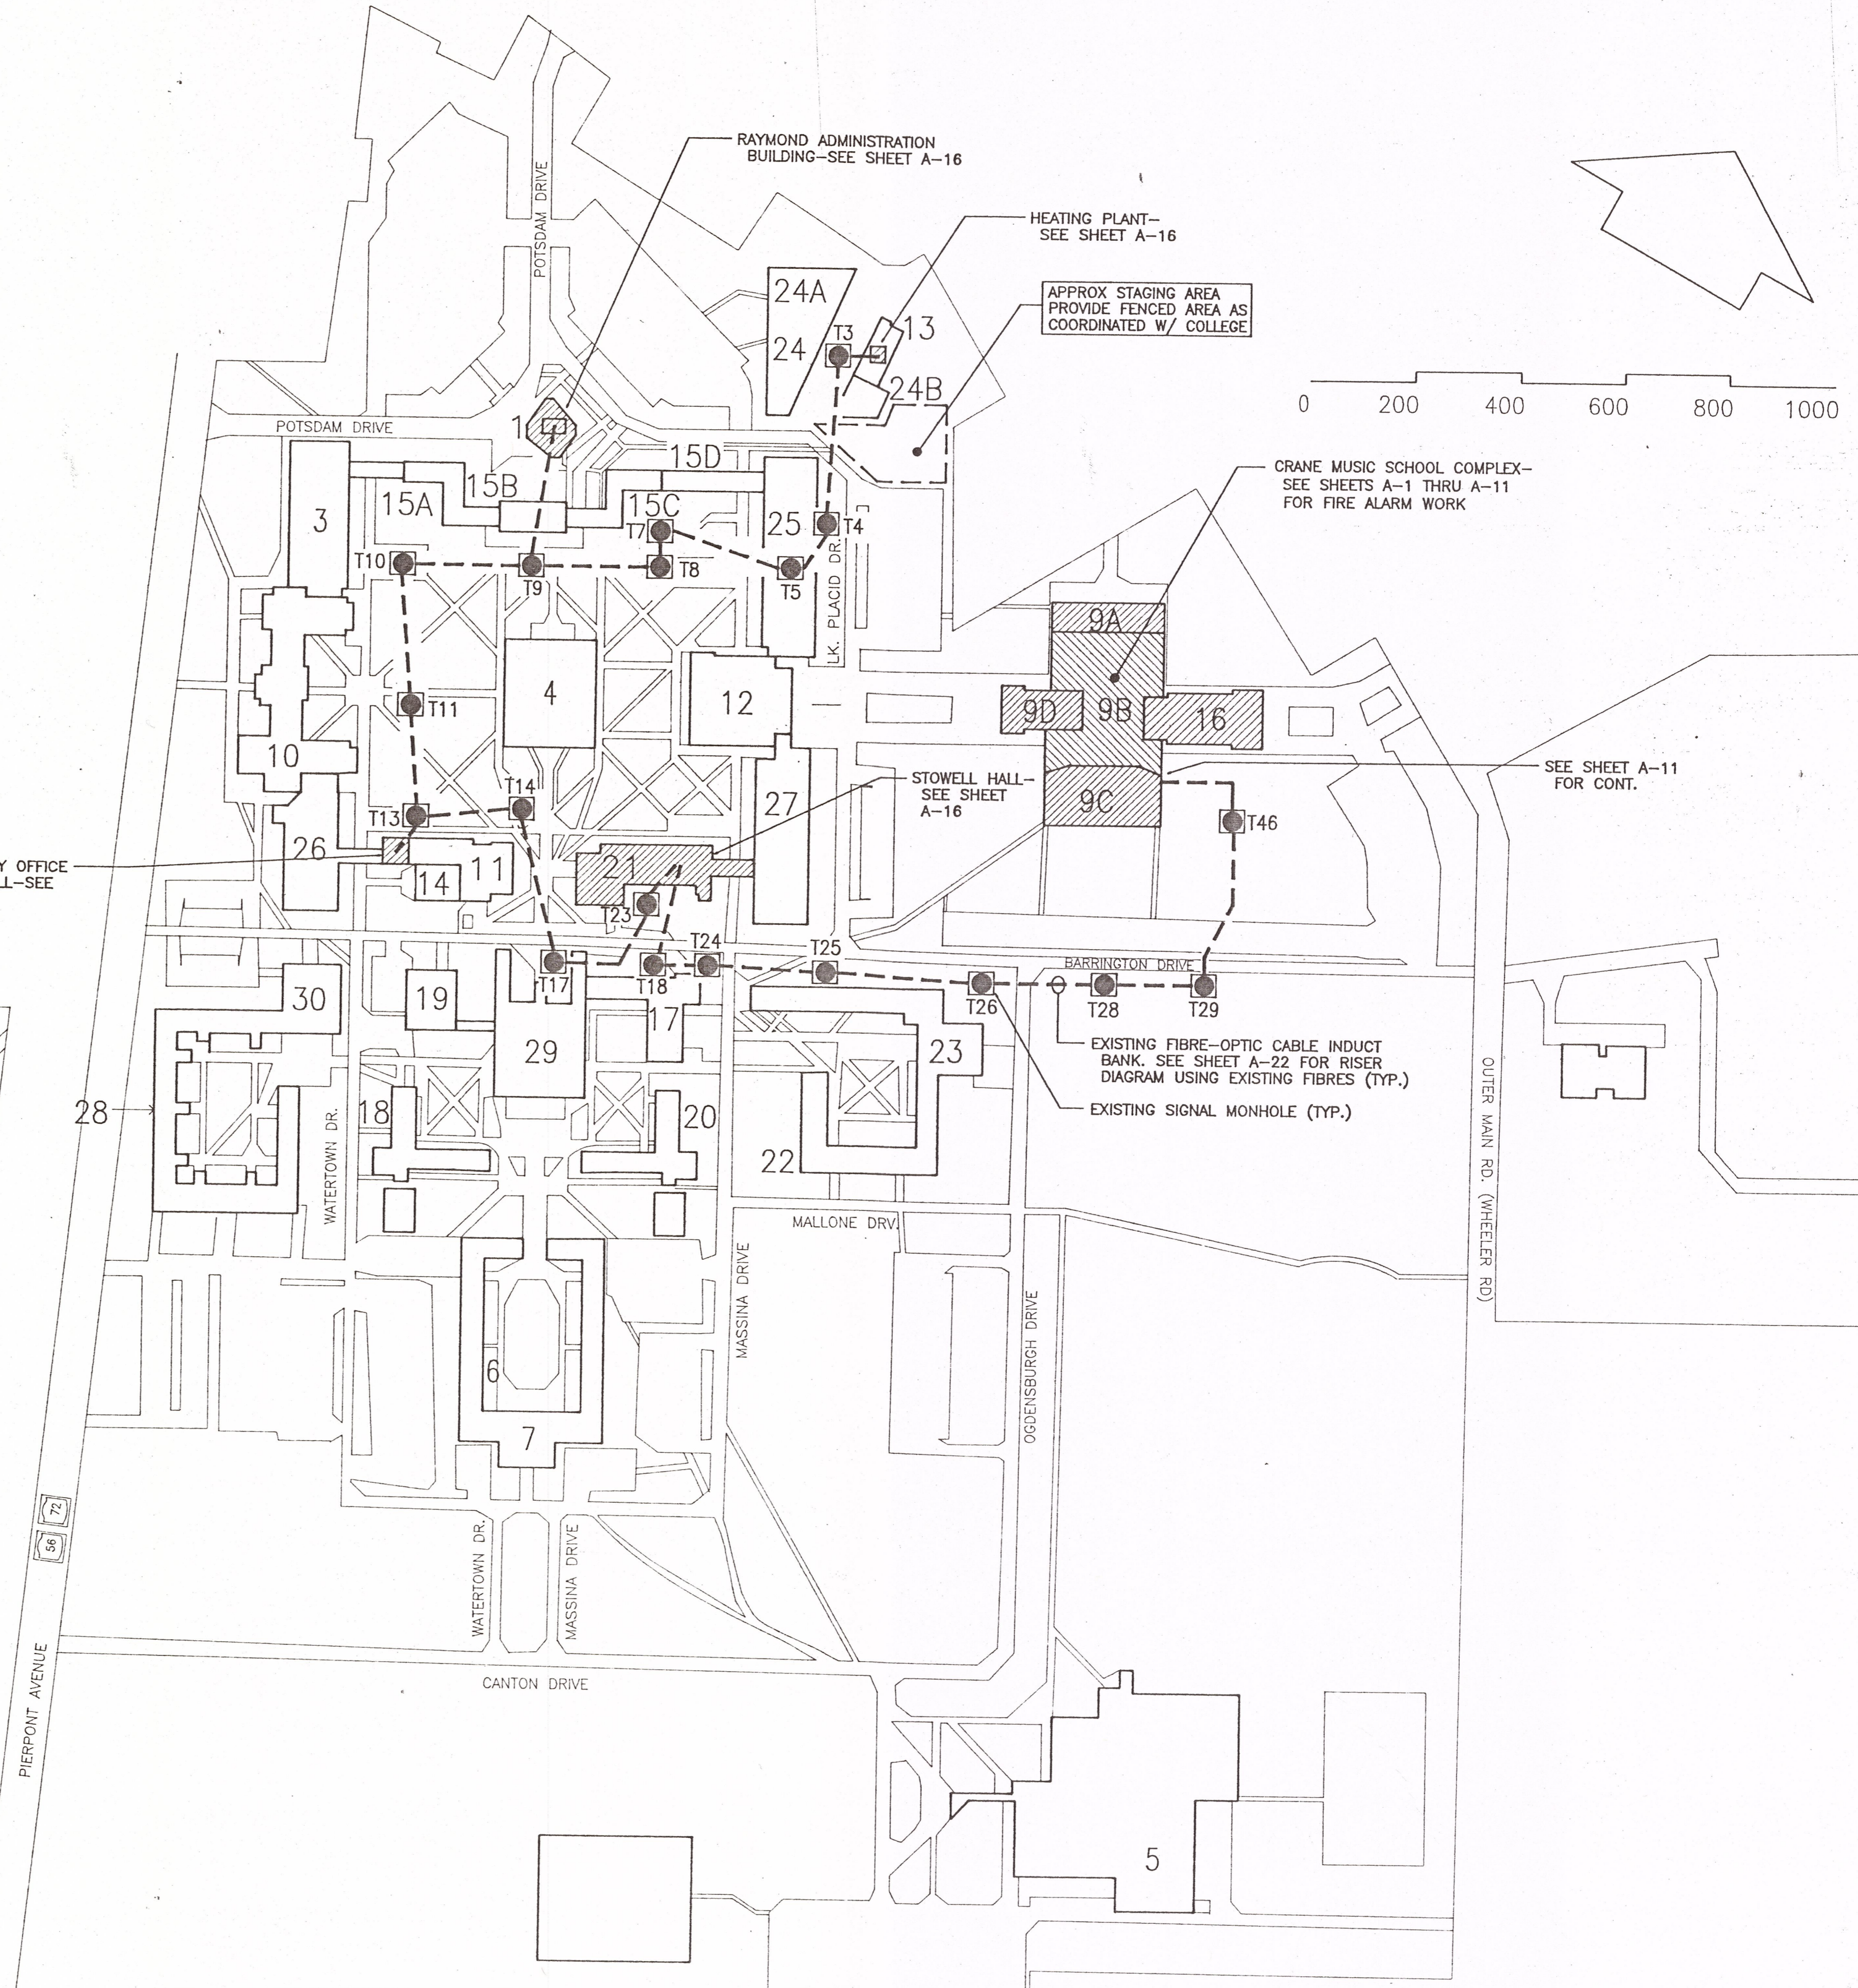


CONTRACTOR SHALL CHECK AND FIELD VERIFY ALL DIMENSIONS AND REPORT DISCREPANCIES TO THE ARCHITECT BEFORE ANY WORK IS COMMENCED.
ALL DRAWINGS ARE THE PROPERTY OF THE ARCHITECT.
THIS DESIGN AND THESE DOCUMENTS MAY NOT BE REPRODUCED, REUSED, ALTERED OR ADDED TO WITHOUT THE WRITTEN PERMISSION OF THE ARCHITECT.

STATE UNIVERSITY
CONSTRUCTION FUND
SUCF PROJECT NUMBER 12130
REPLACE FIRE ALARM SYSTEM / INSTALL SPRINKLER
CRANE MUSIC COMPLEX
STATE UNIVERSITY COLLEGE AT POTSDAM

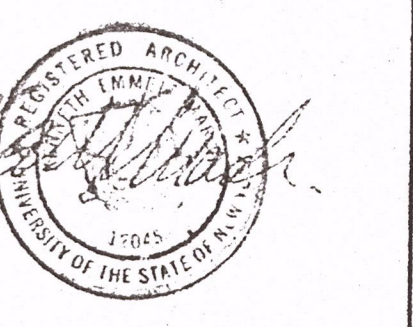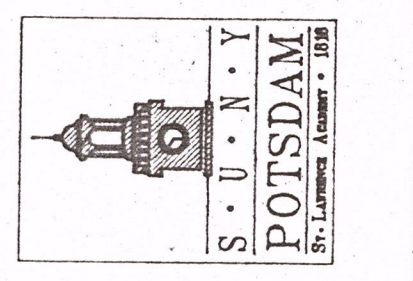

HAZEL CONSULTANTS IN ENGINEERING
P.O. BOX 228
CLIFTON PARK, N.Y. 12065
TEL: (518) 877-8566
FAX: (518) 877-8599

OCM PROJECT NO. 10233

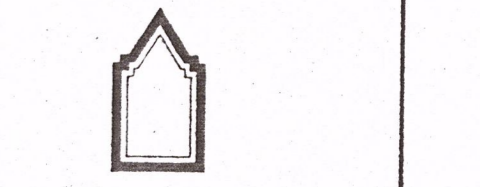

O'CONNOR & MARSH
ARCHITECTS

FACILITY DESIGN - PLANNING

517 OVER THE LIBRARY
WESTERN AVENUE
ALBANY, NEW YORK 12203
518 459 0611

DRAWING TITLE
CAMPUS SITE PLAN

DATE
12-9-97

DRAWING NO.
S1

SUCF PROJECT NO.
12130

D116