


2
S3 TYPICAL TACTILE SIGNAGE LOCATION
SCALE: 1/2" = 1'-0"

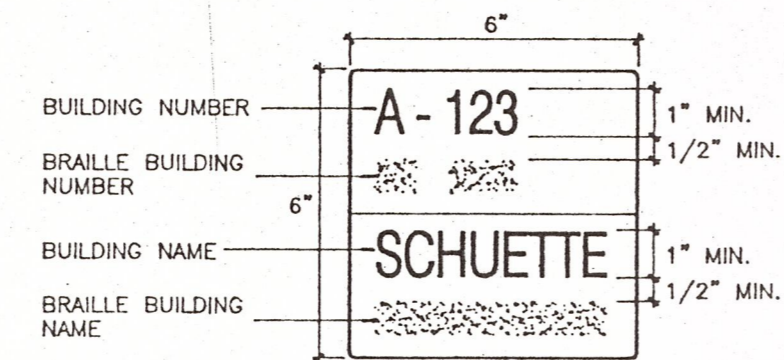

2
S3 DETAIL OF TYPICAL SIGN
NOT TO SCALE


NOTE:
ALL PHYSICAL FEATURES OF
SIGN MUST COMPLY WITH
CABO/ANSI A117.1 AND
APPLICABLE STATE UNIVERSITY
CONSTRUCTION FUND SIGNAGE
GUIDELINES.

DRAWINGS

DRAWING 2/S3

SIGNS - Adden #2
1/7/98

Typical for all sign locations. Contractor remove existing signs and touch up/paint specific area of sign (± 4" beyond existing sign in any direction.)

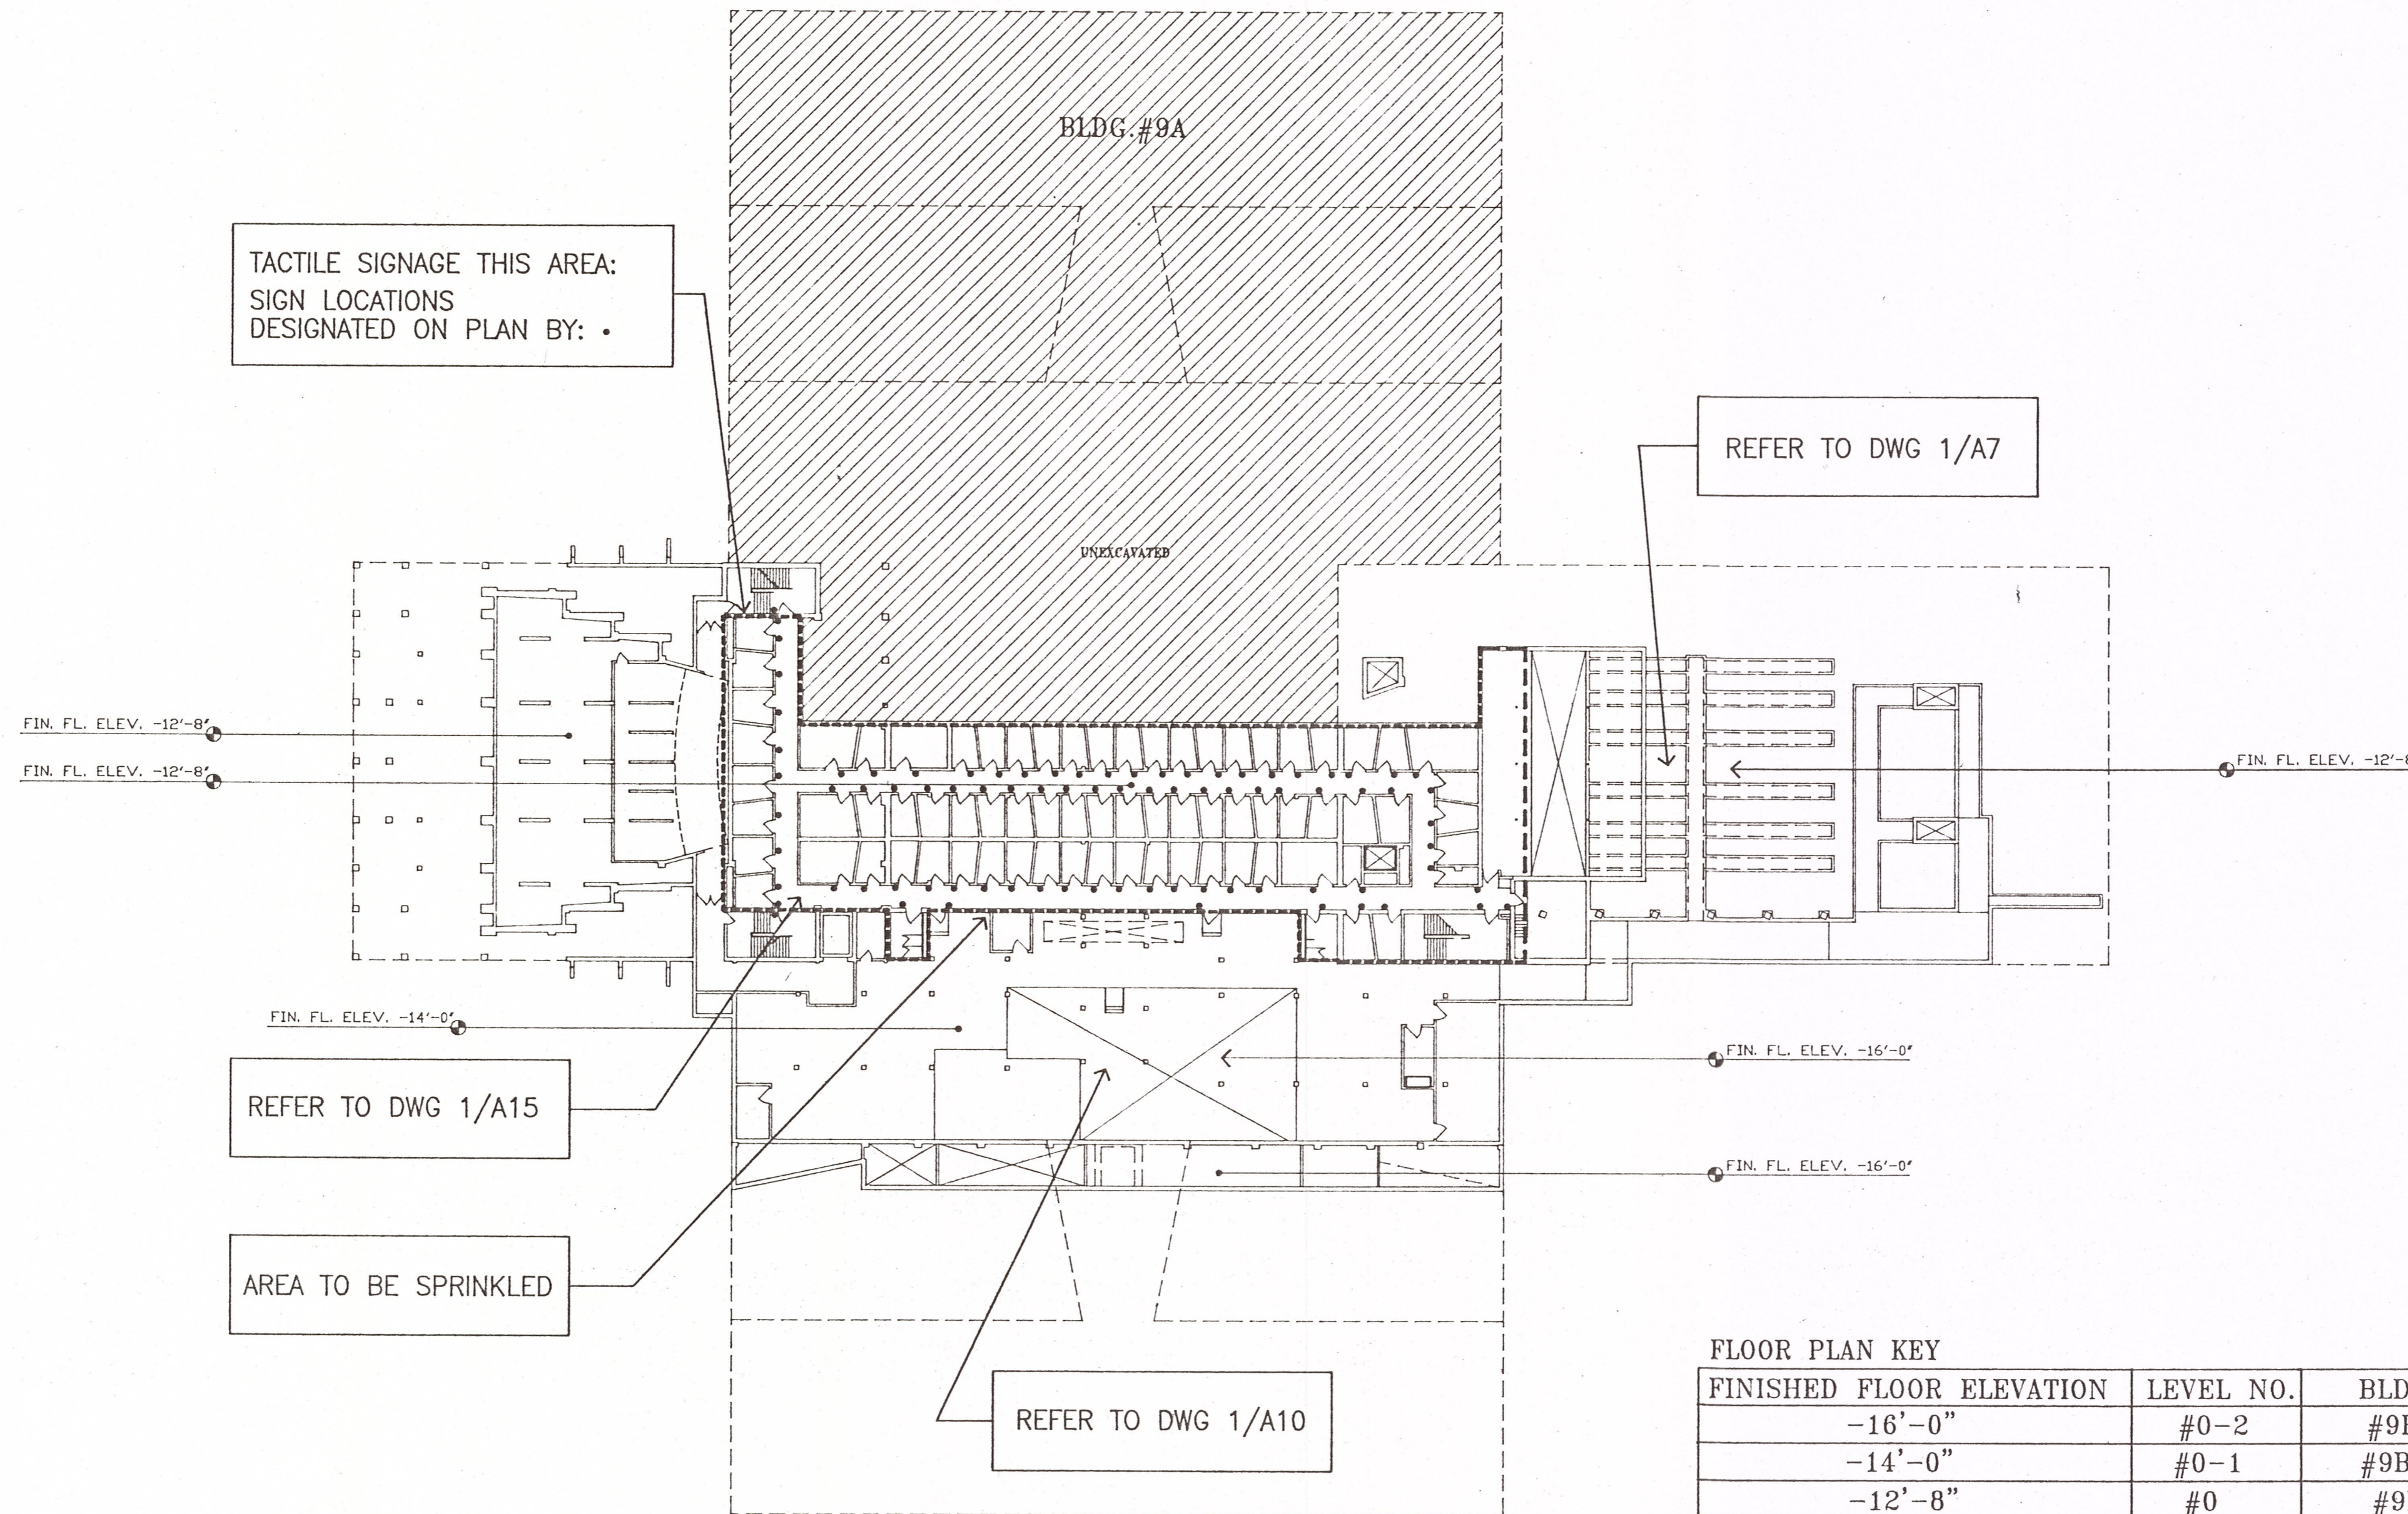

TACTILE SIGNAGE THIS AREA:
SIGN LOCATIONS
DESIGNATED ON PLAN BY: •

REFER TO DWG 1/A7

REFER TO DWG 1/A15


AREA TO BE SPRINKLED

REFER TO DWG 1/A10

FLOOR PLAN KEY


FINISHED FLOOR ELEVATION	LEVEL NO.	BLDG. NO.
-16'-0"	#0-2	#9B,#9C
-14'-0"	#0-1	#9B
-12'-8"	#0	#9B,#9D,#16

1
S3 CRANE MUSIC COMPLEX LEVEL - 0
SCALE: 1/32" = 1'-0"

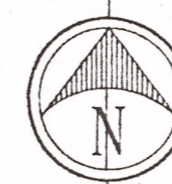


CONTRACTOR SHALL CHECK AND
FIELD VERIFY ALL DIMENSIONS
AND REPORT DISCREPANCIES
TO THE ARCHITECT BEFORE ANY
WORK IS COMMENCED.
ALL DRAWINGS ARE THE PROPERTY
OF THE ARCHITECT.
THIS DESIGN AND THESE DOCU-
MENTS MAY NOT BE REPRODUCED,
REUSED, ALTERED OR ADDED TO
WITHOUT THE WRITTEN PERMISSION
OF THE ARCHITECT.

STATE UNIVERSITY
CONSTRUCTION FUND
SUCF PROJECT NUMBER 12130
REPLACE FIRE ALARM SYSTEM / INSTALL SPRINKLER
CRANE MUSIC COMPLEX
STATE UNIVERSITY COLLEGE AT POTSDAM

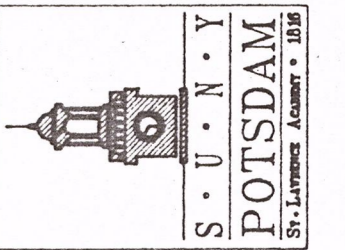

HAZEL CONSULTANTS IN ENGINEERING
P.O. BOX 226
CLIFTON PARK, NY, 12065
TEL: (518) 877-8500
FAX: (518) 877-8500

OCM PROJECT NO. 10233

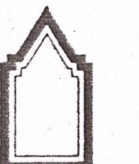

O'CONNOR & MARSH
ARCHITECTS

FACILITY DESIGN - PLANNING

517 OVER THE LIBRARY
WESTERN AVENUE
ALBANY, NEW YORK 12203
518 459 0611

DRAWING TITLE:
CRANE MUSIC COMPLEX,
LEVEL - 0
KEY PLAN AND TACTILE
SIGNAGE DETAILS, LOCATIONS

DATE
12-9-97

DRAWING NO.
S3

SUCF PROJECT NO.
12130

CRANE MUSIC COMPLEX (BLDGS.#9B,#9C,#9D,#16)

D132