
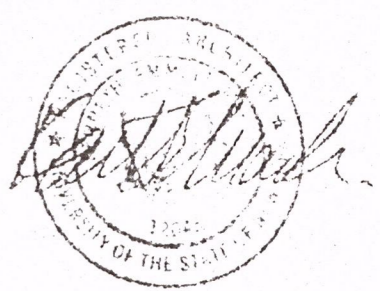


CONTRACTOR SHALL CHECK AND FIELD VERIFY ALL DIMENSIONS AND REPORT DISCREPANCIES TO THE ARCHITECT BEFORE ANY WORK IS COMMENCED.
 ALL DRAWINGS ARE THE PROPERTY OF THE ARCHITECT.
 THIS DESIGN AND THESE DOCUMENTS MAY NOT BE REPRODUCED, REUSED, ALTERED OR ADDED TO WITHOUT THE WRITTEN PERMISSION OF THE ARCHITECT.

STATE UNIVERSITY
 CONSTRUCTION FUND
 SUCF PROJECT NUMBER 12130
 REPLACE FIRE ALARM SYSTEM / INSTALL SPRINKLER
 CRANE MUSIC COMPLEX
 STATE UNIVERSITY COLLEGE AT POTSDAM

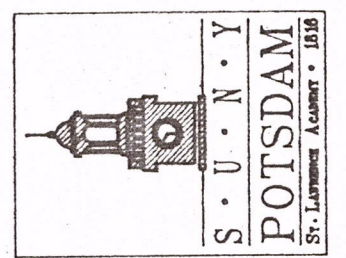

HAZP, CONSULTANTS IN ENGINEERING
 P.O. BOX 228
 CLIFTON PARK, N.Y. 12065
 TEL: (518) 877-8568
 FAX: (518) 877-8599

OCM PROJECT NO. 10233



O'CONNOR & MARSH
 ARCHITECTS


FACILITY DESIGN - PLANNING

517 OVER THE LIBRARY
 WESTERN AVENUE
 ALBANY, NEW YORK 12203
 518 459 0611

DRAWING TITLE
 CRANE MUSIC COMPLEX
 LEVEL - 1
 KEY PLAN AND TACTILE
 SIGNAGE LOCATIONS

DATE
 12-9-97
 DRAWING NO.
 S4
 SUCF PROJECT NO.
 12130

D132

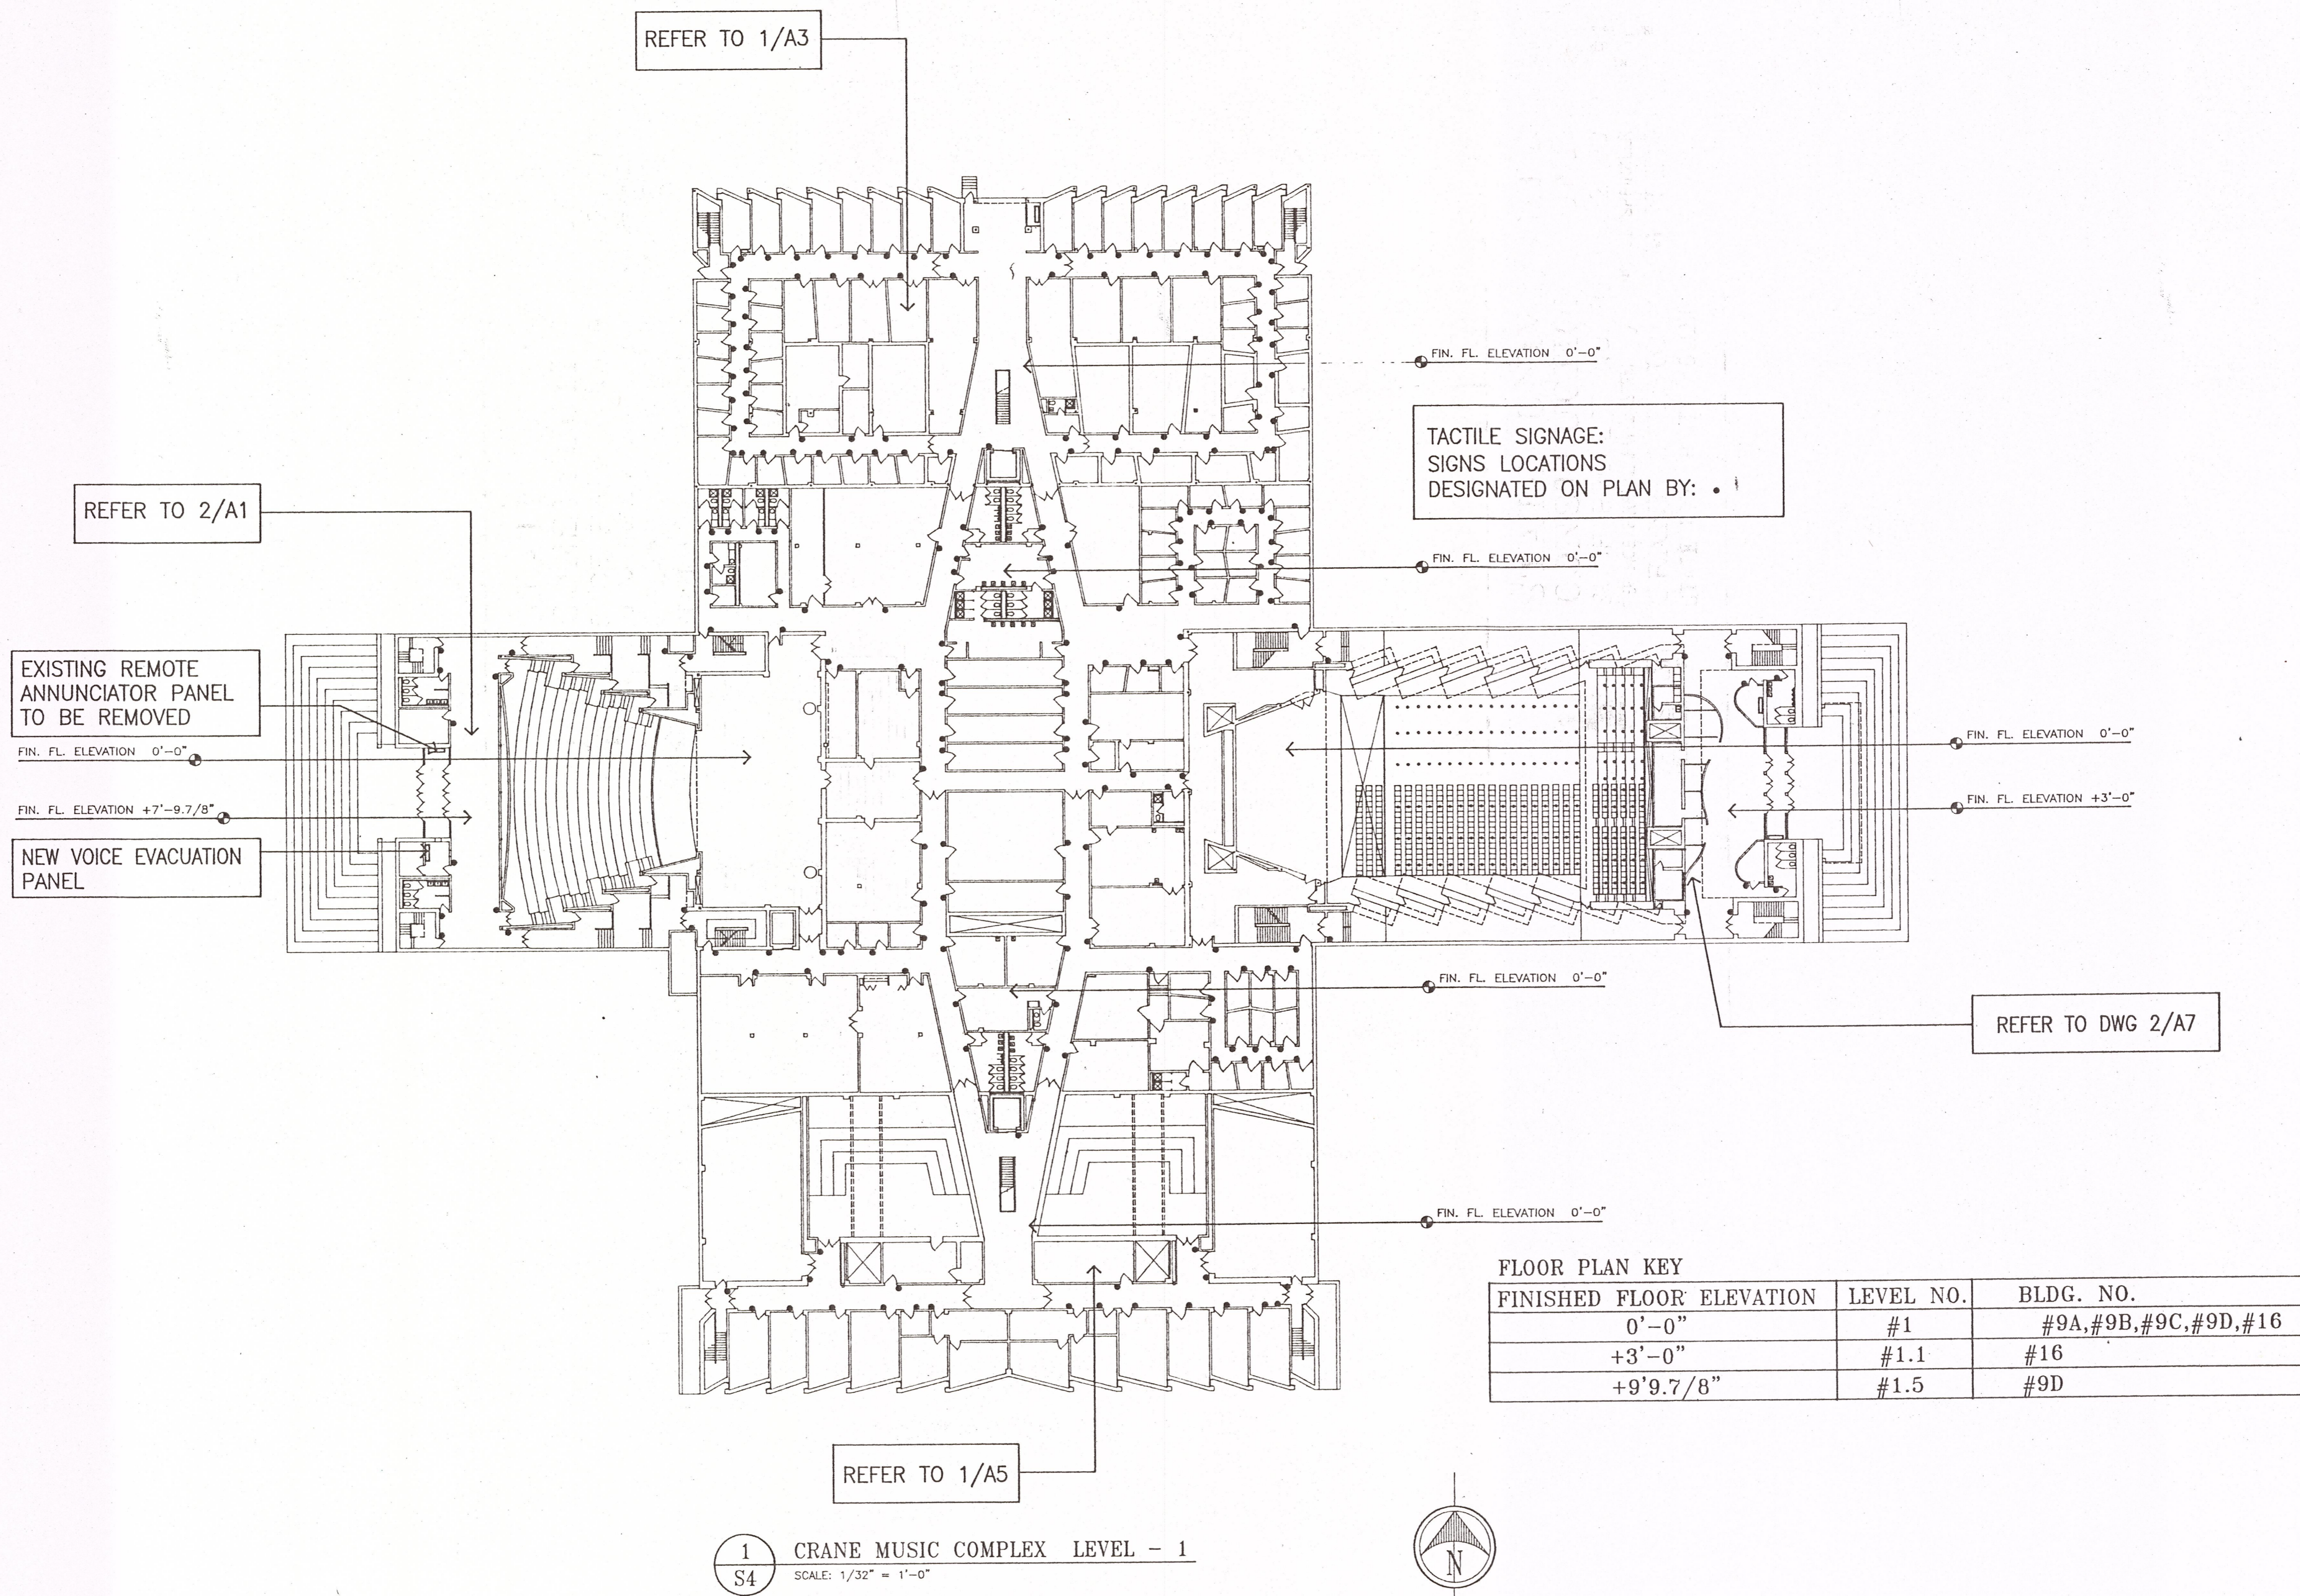

FLOOR PLAN KEY

FINISHED FLOOR ELEVATION	LEVEL NO.	BLDG. NO.
0'-0"	#1	#9A,#9B,#9C,#9D,#16
+3'-0"	#1.1	#16
+9'9.7/8"	#1.5	#9D

1
 S4
 CRANE MUSIC COMPLEX LEVEL - 1
 SCALE: 1/32" = 1'-0"

CRANE MUSIC COMPLEX (BLDG.#9A,#9B,#9C,#9D,#16)